



Procurement #: 54142>

CITY OF PROVIDENCE, RHODE ISLAND

Department: Parks

RFP Title: Site Improvements at Hopkins Sq. Park

Opening Date: 24 Aug 2026

Addendum #: 2

Issuing Date: 12 Aug 2026

The purpose of this addendum is to provide information: please see attached

Providence City Hall
25 Dorrance Street
Providence, RI 02903



WENDY NILSSON
Superintendent of Parks

BRETT P. SMILEY
Mayor

Addendum # 2

RFP: Site Improvements at Hopkins Sq. Park

August 12, 2026

Total Pages Including Cover (26 Pages)

Acknowledge Addenda on Bid Form

**** BID DUE DATE MONDAY, AUGUST 24, 2026, AT 2:15PM ****

Attachments:

1. Addendum Cover Sheet (2 Pages)
2. Pre-Bid Sign-In Sheet (1 Page)
3. Prevailing Wage Decision (16 Pages)
4. RFP Bid Package Specifications (2 Pages)
5. Construction Drawings (5 Pages)
 - a. L-2 Existing Conditions / Demolition Plan
 - b. L-3 Grading Plan
 - c. L-4 Materials Plan
 - d. L-5 Layout Plan
 - e. L-6 Construction Details

Questions/Clarifications:

1. Addendum 2 provides additional specificity to Add/Alt #1 and introduces Add/Alts #2 and #3.
2. Other additions include modifications to the paths, as well as new construction details.
3. Q: "I have a question regarding the RFP Title: Site Improvements at Hopkins Sq. Park.

In section 2.2 OWNER OCCUPANCY REQUIREMENTS

PROVIDENCE PARKS DEPARTMENT
1000 Elmwood Avenue, Providence, RI 02905
Phone: 401-680-7201



WENDY NILSSON
Superintendent of Parks

BRETT P. SMILEY
Mayor

A. The Owner (City) anticipates that site inclusive of all on-site amenities beyond the Limit of Work will remain open throughout the course of construction.

I want to clarify that we can fence off the entire park to the LOW line on the plans.”

A: The Limit of Work (LOW) line, as described in Specification Section 010000, 2.1 Contractor Use of Premises, A., indicates the limits of” the Contractor’s uses of premises.”

Since most construction projects happen in phases and not all at once, in most instances, we try to keep parks open for use by the owner and the public. Fencing off an entire park largely depends on the Contractor’s plan of execution and project schedule. If the intent is to perform demolition and installation of all areas within a short timeframe, fencing off an entire park may be warranted. Otherwise, temporary fencing is mainly required for protection of City’s existing assets, such as trees, amenities and equipment, and during active construction when the areas under immediate construction pose potential hazards or the work requires limited access.

Sign-In Sheet

Non-Mandatory Pre-Bid Meeting

August, 12, 2026 at 10:00 AM – 465 Branch Ave, Providence, RI (Site)

Project: Site Improvements at Hopkins Sq. Park

NAME	COMPANY	E-MAIL	PHONE
Chris Reynolds	Pubm Masonry	CReynolds@pubmasonry.com	401-500-5062
Bill BRYANT	SITE TECH	BillB@SITE TECH CORP.COM	401-490-7483
Rich Oliveira	RISD Construction	risdconstruction@gmail.com	401-660-7044
Dante Antonelli	Antonelli and Sons	dantemantonelli@gmail.com	401-500-6813

"General Decision Number: RI20260001 07/30/2026

State: Rhode Island

Construction Types: Building, Heavy and Highway

Counties: Rhode Island Counties of
Bristol, Kent, Newport, Providence and
Washington

Includes Marine Construction Projects

Modification Number	Publication Date
2	01/30/2026
3	05/18/2026
4	07/30/2026

ASBE0006-006 09/01/2024		
	Rates	Fringes
HAZARDOUS MATERIAL HANDLER (INCLUDES PREPARATION, WETTING, STRIPPING, REMOVAL SCRAPPING, VACUUMING, BAGGING & DISPOSING OF ALL INSULATION MATERIALS, WHETHER THEY CONTAIN ASBESTOS OR NOT, FROM MECHANICAL SYSTEMS).....	\$ 49.91	36.63

ASBE0006-008 09/01/2024		
	Rates	Fringes
ASBESTOS WORKER/INSULATOR (INCLUDES APPLICATION OF ALL INSULATING MATERIALS, PROTECTIVE COVERINGS, COATINGS & FINISHES TO ALL TYPES OF MECHANICAL SYSTEMS).....	\$ 49.91	36.63

BOIL0029-001 01/01/2025		
	Rates	Fringes
BOILERMAKER.....	\$ 50.62	28.82

BRI0003-001 06/01/2022		
	Rates	Fringes
BRICKLAYER, STONEMASON, POINTER, CAULKER & CLEANER..	\$ 46.86	29.14

BRI0003-002 09/01/2022		
	Rates	Fringes
MARBLE SETTER, TERRAZZO WORKER & TILE SETTER.....	\$ 46.54	30.34

BRI0003-003 09/01/2022		
	Rates	Fringes
MARBLE, TILE & TERRAZZO FINISHER.....	\$ 38.78	29.61

CARP0330-001 06/02/2025		
	Rates	Fringes
DIVER (WHEN NOT DIVING OR TENDING THE DIVER, THE DIVER AND DIVER TENDER SHALL RECEIVE THE PILEDRIVER RATE. DIVER TENDERS SHALL RECEIVE \$1.00 PER HOUR ABOVE THE PILE DRIVER RATE WHEN TENDING THE DIVER.)	\$ 60.83	30.50

DIVER TENDER (WHEN NOT DIVING OR TENDING THE DIVER, THE DIVER AND DIVER TENDER SHALL RECEIVE THE PILEDRIVER RATE. DIVER TENDERS SHALL RECEIVE \$1.00 PER HOUR ABOVE THE PILE DRIVER RATE WHEN TENDING THE DIVER.)	\$ 48.68	30.50
CARPENTER: INCLUDES SOFT FLOOR LAYER (WORK ON FREE-STANDING STACKS, CONCRETE SILOS & PUBLIC UTILITY ELECTRICAL POWER HOUSES, WHICH ARE OVER 35 FT. IN HEIGHT WHEN CONSTRUCTED: \$.50 PER HOUR ADDITIONAL. WORK ON EXTERIOR CONCRETE SHEAR WALL GANG FORMS, 45 FT. OR MORE ABOVE GROUND ELEVATION OR ON SETBACK: \$.50 PER HOUR ADDITIONAL.).....	\$ 47.88	30.50
PILEDRIVER (WORK ON FREE-STANDING STACKS, CONCRETE SILOS & PUBLIC UTILITY ELECTRICAL POWER HOUSES, WHICH ARE OVER 35 FT. IN HEIGHT WHEN CONSTRUCTED: \$.50 PER HOUR ADDITIONAL. WORK ON EXTERIOR CONCRETE SHEAR WALL GANG FORMS, 45 FT. OR MORE ABOVE GROUND ELEVATION OR ON SETBACK: \$.50 PER HOUR ADDITIONAL. THE DESIGNATED PILEDRIVER, KNOWN AS THE ""MONKEY"": \$1.00 PER HOUR ADDITIONAL.....)	\$ 41.53	29.35
WELDER (WORK ON FREE-STANDING STACKS, CONCRETE SILOS & PUBLIC UTILITY ELECTRICAL POWER HOUSES, WHICH ARE OVER 35 FT. IN HEIGHT WHEN CONSTRUCTED: \$.50 PER HOUR ADDITIONAL. WORK ON EXTERIOR CONCRETE SHEAR WALL GANG FORMS, 45 FT. OR MORE ABOVE GROUND ELEVATION OR ON SETBACK: \$.50 PER HOUR ADDITIONAL.)	\$ 48.68	30.50

CARP1121-002 04/21/2025	Rates	Fringes
MILLWRIGHT.....)	\$ 45.72	31.50

ELEC0099-002 06/01/2025	Rates	Fringes
ELECTRICIAN (WORK OF A HAZARDOUS NATURE, OR WHERE THE WORK HEIGHT IS 30 FT. OR MORE FROM THE FLOOR, EXCEPT WHEN WORKING OSHA-APPROVED LIFTS: 20% PER HOUR ADDITIONAL. WORK IN TUNNELS BELOW GROUND LEVEL IN COMBINED SEWER OUTFALL: 20% PER HOUR ADDITIONAL.).....)	\$ 56.11	24.74
TELEDATA SYSTEM INSTALLER (WORK OF A HAZARDOUS NATURE, OR WHERE THE WORK HEIGHT IS 30 FT. OR MORE FROM THE FLOOR, EXCEPT WHEN WORKING OSHA-APPROVED LIFTS: 20% PER HOUR ADDITIONAL. WORK IN TUNNELS BELOW GROUND LEVEL IN COMBINED SEWER OUTFALL: 20% PER HOUR ADDITIONAL.).....)	\$ 42.09	19.71

ELEV0039-001 01/01/2025	Rates	Fringes
ELEVATOR MECHANIC (ADDITIONAL FRINGE TO BE PAID A. PAID HOLIDAYS: NEW YEARS DAY; MEMORIAL DAY; INDEPENDENCE DAY; LABOR DAY; VETERANS' DAY; THANKSGIVING DAY; THE FRIDAY AFTER THANKSGIVING DAY; AND CHRISTMAS DAY. B. EMPLOYER CONTRIBUTES 8% BASIC HOURLY RATE FOR 5 YEARS OR MORE OF SERVICE OF 6% BASIC HOURLY RATE FOR 6 MONTHS TO 5 YEARS OF SERVICE AS VACATION PAY CREDIT.).....)	\$ 64.52	38.44

ENGI0057-001 12/01/2025	Rates	Fringes
POWER EQUIPMENT OPERATOR: POWER PLANTS, SEWER TREATMENT PLANTS, PUMPING STATIONS, TUNNELS, CAISSONS, PIERS, DOCKS, BRIDGES, WIND TURBINES, SUBTERRANEAN & OTHER MARINE AND HEAVY CONSTRUCTION WORK: GROUP 1: CRANES, LIGHTERS, BOOM TRUCKS AND DERRICKS. (BOOM LENGTHS, INCLUDING JIBS: 150 FEET		

AND OVER + \$ 2.00; 180 FEET AND OVER + \$ 3.00;
 210 FEET AND OVER + \$ 4.00; 240 FEET AND OVER + \$
 5.00; 270 FEET AND OVER + \$ 7.00; 300 FEET AND
 OVER + \$ 8.00; 350 FEET AND OVER + \$ 9.00; 400
 FEET AND OVER + \$10.00); (PAID HOLIDAYS: NEW
 YEAR'S DAY, PRESIDENT'S DAY, MEMORIAL DAY, JULY
 FOURTH, VICTORY DAY, LABOR DAY, COLUMBUS DAY,
 VETERANS DAY, THANKSGIVING DAY, CHRISTMAS DAY. ANY
 EMPLOYEE WHO WORKS 3 DAYS IN THE WEEK IN WHICH A
 HOLIDAY FALLS SHALL BE PAID FOR THE HOLIDAY.)
 (HAZMAT WORK: \$2.00 PER HOUR ADDITIONAL.
 TUNNEL/SHAFT WORK: \$5.00 PER HOUR ADDITIONAL.).....\$ 51.30 29.95
 POWER EQUIPMENT OPERATOR: POWER PLANTS, SEWER
 TREATMENT PLANTS, PUMPING STATIONS, TUNNELS,
 CAISSONS, PIERS, DOCKS, BRIDGES, WIND TURBINES,
 SUBTERRANEAN & OTHER MARINE AND HEAVY CONSTRUCTION
 WORK: GROUP 2: DIGGING MACHINE, ROSS CARRIER,
 LOCOMOTIVE, HOIST, ELEVATOR, BIDWELL-TYPE MACHINE,
 SHOT & WATER BLASTING MACHINE, PAVER, SPREADER,
 GRADERS, FRONT END LOADER (3 YDS. AND OVER),
 VIBRATORY HAMMER & VACUUM TRUCK, ROADHEADERS,
 FORKLIFTS, ECONOMOBILE TYPE EQUIPMENT, TUNNEL
 BORING MACHINES, CONCRETE PUMP AND ON SITE CONCRETE
 PLANTS. (BOOM LENGTHS, INCLUDING JIBS: 150 FEET
 AND OVER + \$ 2.00; 180 FEET AND OVER + \$ 3.00;
 210 FEET AND OVER + \$ 4.00; 240 FEET AND OVER + \$
 5.00; 270 FEET AND OVER + \$ 7.00; 300 FEET AND
 OVER + \$ 8.00; 350 FEET AND OVER + \$ 9.00; 400
 FEET AND OVER + \$10.00); (PAID HOLIDAYS: NEW
 YEAR'S DAY, PRESIDENT'S DAY, MEMORIAL DAY, JULY
 FOURTH, VICTORY DAY, LABOR DAY, COLUMBUS DAY,
 VETERANS DAY, THANKSGIVING DAY, CHRISTMAS DAY. ANY
 EMPLOYEE WHO WORKS 3 DAYS IN THE WEEK IN WHICH A
 HOLIDAY FALLS SHALL BE PAID FOR THE HOLIDAY.)
 (HAZMAT WORK: \$2.00 PER HOUR ADDITIONAL.
 TUNNEL/SHAFT WORK: \$5.00 PER HOUR ADDITIONAL.).....\$ 49.30 29.95
 POWER EQUIPMENT OPERATOR: POWER PLANTS, SEWER
 TREATMENT PLANTS, PUMPING STATIONS, TUNNELS,
 CAISSONS, PIERS, DOCKS, BRIDGES, WIND TURBINES,
 SUBTERRANEAN & OTHER MARINE AND HEAVY CONSTRUCTION
 WORK: GROUP 3: OILERS ON CRANES. (BOOM LENGTHS,
 INCLUDING JIBS: 150 FEET AND OVER + \$ 2.00; 180
 FEET AND OVER + \$ 3.00; 210 FEET AND OVER + \$
 4.00; 240 FEET AND OVER + \$ 5.00; 270 FEET AND
 OVER + \$ 7.00; 300 FEET AND OVER + \$ 8.00; 350
 FEET AND OVER + \$ 9.00; 400 FEET AND OVER +
 \$10.00); (PAID HOLIDAYS: NEW YEAR'S DAY,
 PRESIDENT'S DAY, MEMORIAL DAY, JULY FOURTH, VICTORY
 DAY, LABOR DAY, COLUMBUS DAY, VETERANS DAY,
 THANKSGIVING DAY, CHRISTMAS DAY. ANY EMPLOYEE WHO
 WORKS 3 DAYS IN THE WEEK IN WHICH A HOLIDAY FALLS
 SHALL BE PAID FOR THE HOLIDAY.) (HAZMAT WORK:
 \$2.00 PER HOUR ADDITIONAL. TUNNEL/SHAFT WORK:
 \$5.00 PER HOUR ADDITIONAL.).....\$ 44.92 29.95
 POWER EQUIPMENT OPERATOR: POWER PLANTS, SEWER
 TREATMENT PLANTS, PUMPING STATIONS, TUNNELS,
 CAISSONS, PIERS, DOCKS, BRIDGES, WIND TURBINES,
 SUBTERRANEAN & OTHER MARINE AND HEAVY CONSTRUCTION
 WORK: GROUP 4: OILER ON CRAWLER BACKHOE. (BOOM
 LENGTHS, INCLUDING JIBS: 150 FEET AND OVER + \$
 2.00; 180 FEET AND OVER + \$ 3.00; 210 FEET AND
 OVER + \$ 4.00; 240 FEET AND OVER + \$ 5.00; 270
 FEET AND OVER + \$ 7.00; 300 FEET AND OVER + \$
 8.00; 350 FEET AND OVER + \$ 9.00; 400 FEET AND
 OVER + \$10.00); (PAID HOLIDAYS: NEW YEAR'S DAY,
 PRESIDENT'S DAY, MEMORIAL DAY, JULY FOURTH, VICTORY
 DAY, LABOR DAY, COLUMBUS DAY, VETERANS DAY,
 THANKSGIVING DAY, CHRISTMAS DAY. ANY EMPLOYEE WHO
 WORKS 3 DAYS IN THE WEEK IN WHICH A HOLIDAY FALLS
 SHALL BE PAID FOR THE HOLIDAY.) (HAZMAT WORK:

\$2.00 PER HOUR ADDITIONAL. TUNNEL/SHAFT WORK:
\$5.00 PER HOUR ADDITIONAL.) ...\$ 42.07 29.95
POWER EQUIPMENT OPERATOR: POWER PLANTS, SEWER
TREATMENT PLANTS, PUMPING STATIONS, TUNNELS,
CAISSONS, PIERS, DOCKS, BRIDGES, WIND TURBINES,
SUBTERRANEAN & OTHER MARINE AND HEAVY CONSTRUCTION
WORK: GROUP 5: BULLDOZER, BOBCATS, SKID STEER
LOADER, TRACTOR, SCRAPER, COMBINATION LOADER
BACKHOE, ROLLER, FRONT END LOADER (LESS THAN 3
YDS.), STREET AND MOBILE-POWERED SWEEPER (3-YD.
CAPACITY), 8-FT. SWEEPER MINIMUM 65 HP). (BOOM
LENGTHS, INCLUDING JIBS: 150 FEET AND OVER +
\$2.00; 180 FEET AND OVER + \$ 3.00; 210 FEET AND
OVER + \$ 4.00; 240 FEET AND OVER + \$ 5.00; 270
FEET AND OVER + \$ 7.00; 300 FEET AND OVER + \$
8.00; 350 FEET AND OVER + \$ 9.00; 400 FEET AND
OVER + \$10.00); (PAID HOLIDAYS: NEW YEAR'S DAY,
PRESIDENT'S DAY, MEMORIAL DAY, JULY FOURTH, VICTORY
DAY, LABOR DAY, COLUMBUS DAY, VETERANS DAY,
THANKSGIVING DAY, CHRISTMAS DAY. ANY EMPLOYEE WHO
WORKS 3 DAYS IN THE WEEK IN WHICH A HOLIDAY FALLS
SHALL BE PAID FOR THE HOLIDAY.) (HAZMAT WORK:
\$2.00 PER HOUR ADDITIONAL. TUNNEL/SHAFT WORK:
\$5.00 PER HOUR ADDITIONAL.).....\$ 48.35 29.95
POWER EQUIPMENT OPERATOR: POWER PLANTS, SEWER
TREATMENT PLANTS, PUMPING STATIONS, TUNNELS,
CAISSONS, PIERS, DOCKS, BRIDGES, WIND TURBINES,
SUBTERRANEAN & OTHER MARINE AND HEAVY CONSTRUCTION
WORK: GROUP 6: WELL-POINT INSTALLATION CREW. (BOOM
LENGTHS, INCLUDING JIBS: 150 FEET AND OVER + \$
2.00; 180 FEET AND OVER + \$ 3.00; 210 FEET AND
OVER + \$ 4.00; 240 FEET AND OVER + \$ 5.00; 270
FEET AND OVER + \$ 7.00; 300 FEET AND OVER + \$
8.00; 350 FEET AND OVER + \$ 9.00; 400 FEET AND
OVER + \$10.00); (PAID HOLIDAYS: NEW YEAR'S DAY,
PRESIDENT'S DAY, MEMORIAL DAY, JULY FOURTH, VICTORY
DAY, LABOR DAY, COLUMBUS DAY, VETERANS DAY,
THANKSGIVING DAY, CHRISTMAS DAY. ANY EMPLOYEE WHO
WORKS 3 DAYS IN THE WEEK IN WHICH A HOLIDAY FALLS
SHALL BE PAID FOR THE HOLIDAY.) (HAZMAT WORK:
\$2.00 PER HOUR ADDITIONAL. TUNNEL/SHAFT WORK:
\$5.00 PER HOUR ADDITIONAL.).....\$ 39.15 29.95
POWER EQUIPMENT OPERATOR: POWER PLANTS, SEWER
TREATMENT PLANTS, PUMPING STATIONS, TUNNELS,
CAISSONS, PIERS, DOCKS, BRIDGES, WIND TURBINES,
SUBTERRANEAN & OTHER MARINE AND HEAVY CONSTRUCTION
WORK: GROUP 7: UTILITY ENGINEERS AND SIGNAL
PERSONS. (BOOM LENGTHS, INCLUDING JIBS: 150 FEET
AND OVER + \$ 2.00; 180 FEET AND OVER + \$ 3.00;
210 FEET AND OVER + \$ 4.00; 240 FEET AND OVER + \$
5.00; 270 FEET AND OVER + \$ 7.00; 300 FEET AND
OVER + \$ 8.00; 350 FEET AND OVER + \$ 9.00; 400
FEET AND OVER + \$10.00); (PAID HOLIDAYS: NEW
YEAR'S DAY, PRESIDENT'S DAY, MEMORIAL DAY, JULY
FOURTH, VICTORY DAY, LABOR DAY, COLUMBUS DAY,
VETERANS DAY, THANKSGIVING DAY, CHRISTMAS DAY. ANY
EMPLOYEE WHO WORKS 3 DAYS IN THE WEEK IN WHICH A
HOLIDAY FALLS SHALL BE PAID FOR THE HOLIDAY.)
(HAZMAT WORK: \$2.00 PER HOUR ADDITIONAL.
TUNNEL/SHAFT WORK: \$5.00 PER HOUR ADDITIONAL.).....\$ 33.15 29.95
POWER EQUIPMENT OPERATOR: POWER PLANTS, SEWER
TREATMENT PLANTS, PUMPING STATIONS, TUNNELS,
CAISSONS, PIERS, DOCKS, BRIDGES, WIND TURBINES,
SUBTERRANEAN & OTHER MARINE AND HEAVY CONSTRUCTION
WORK: GROUP 8: HEATER, CONCRETE MIXER, STONE
CRUSHER, WELDING MACHINE, GENERATOR AND LIGHT
PLANT, GAS AND ELECTRIC DRIVEN PUMP AND AIR
COMPRESSOR. (BOOM LENGTHS, INCLUDING JIBS: 150
FEET AND OVER + \$ 2.00; 180 FEET AND OVER + \$
3.00; 210 FEET AND OVER + \$ 4.00; 240 FEET AND

OVER + \$ 5.00; 270 FEET AND OVER + \$ 7.00; 300 FEET AND OVER + \$ 8.00; 350 FEET AND OVER + \$ 9.00; 400 FEET AND OVER + \$10.00); (PAID HOLIDAYS: NEW YEAR'S DAY, PRESIDENT'S DAY, MEMORIAL DAY, JULY FOURTH, VICTORY DAY, LABOR DAY, COLUMBUS DAY, VETERANS DAY, THANKSGIVING DAY, CHRISTMAS DAY. ANY EMPLOYEE WHO WORKS 3 DAYS IN THE WEEK IN WHICH A HOLIDAY FALLS SHALL BE PAID FOR THE HOLIDAY.) (HAZMAT WORK: \$2.00 PER HOUR ADDITIONAL. TUNNEL/SHAFT WORK: \$5.00 PER HOUR ADDITIONAL.).....\$ 45.00 29.95

POWER EQUIPMENT OPERATOR: POWER PLANTS, SEWER TREATMENT PLANTS, PUMPING STATIONS, TUNNELS, CAISSONS, PIERS, DOCKS, BRIDGES, WIND TURBINES, SUBTERRANEAN & OTHER MARINE AND HEAVY CONSTRUCTION WORK: GROUP 9: BOAT & TUG OPERATOR. (BOOM LENGTHS, INCLUDING JIBS: 150 FEET AND OVER + \$ 2.00; 180 FEET AND OVER + \$ 3.00; 210 FEET AND OVER + \$ 4.00; 240 FEET AND OVER + \$ 5.00; 270 FEET AND OVER + \$ 7.00; 300 FEET AND OVER + \$ 8.00; 350 FEET AND OVER + \$ 9.00; 400 FEET AND OVER + \$10.00); (PAID HOLIDAYS: NEW YEAR'S DAY, PRESIDENT'S DAY, MEMORIAL DAY, JULY FOURTH, VICTORY DAY, LABOR DAY, COLUMBUS DAY, VETERANS DAY, THANKSGIVING DAY, CHRISTMAS DAY. ANY EMPLOYEE WHO WORKS 3 DAYS IN THE WEEK IN WHICH A HOLIDAY FALLS SHALL BE PAID FOR THE HOLIDAY.) (HAZMAT WORK: \$2.00 PER HOUR ADDITIONAL. TUNNEL/SHAFT WORK: \$5.00 PER HOUR ADDITIONAL.).....\$ 48.92 29.95

ENGI0057-003 12/01/2025

Rates

Fringes

POWER EQUIPMENT OPERATOR: BUILDING CONSTRUCTION: GROUP 1: CRANES, LIGHTERS, BOOM TRUCKS AND DERRICKS. (BOOM LENGTHS, INCLUDING JIBS: 150 FT. AND OVER: + \$ 2.00; 180 FT. AND OVER: + \$ 3.00; 210 FT. AND OVER: + \$ 4.00; 240 FT. AND OVER: + \$ 5.00; 270 FT. AND OVER: + \$ 7.00; 300 FT. AND OVER: + \$ 8.00; 350 FT. AND OVER: + \$ 9.00; 400 FT. AND OVER: + \$10.00) (PAID HOLIDAYS: NEW YEAR'S DAY, PRESIDENT'S DAY, MEMORIAL DAY, JULY FOURTH, VICTORY DAY, LABOR DAY, COLUMBUS DAY, VETERANS DAY, THANKSGIVING DAY & CHRISTMAS DAY. A: ANY EMPLOYEE WHO WORKS 3 DAYS IN THE WEEK IN WHICH A HOLIDAY FALLS SHALL BE PAID FOR THE HOLIDAY.) (HAZMAT WORK: \$2.00 PER HOUR ADDITIONAL. TUNNEL/SHAFT WORK: \$5.00 PER HOUR ADDITIONAL.).....\$ 50.57 29.95

POWER EQUIPMENT OPERATOR: BUILDING CONSTRUCTION: GROUP 2: DIGGING MACHINE, ROSS CARRIER, LOCOMOTIVE, HOIST, ELEVATOR, BIDWELL-TYPE MACHINE, SHOT & WATER BLASTING MACHINE, PAVER, SPREADER, FRONT END LOADER (3 YDS. AND OVER), VIBRATORY HAMMER AND VACUUM TRUCK. (BOOM LENGTHS, INCLUDING JIBS: 150 FT. AND OVER: + \$ 2.00; 180 FT. AND OVER: + \$ 3.00; 210 FT. AND OVER: + \$ 4.00; 240 FT. AND OVER: + \$ 5.00; 270 FT. AND OVER: + \$ 7.00; 300 FT. AND OVER: + \$ 8.00; 350 FT. AND OVER: + \$ 9.00; 400 FT. AND OVER: + \$10.00) (PAID HOLIDAYS: NEW YEAR'S DAY, PRESIDENT'S DAY, MEMORIAL DAY, JULY FOURTH, VICTORY DAY, LABOR DAY, COLUMBUS DAY, VETERANS DAY, THANKSGIVING DAY & CHRISTMAS DAY. A: ANY EMPLOYEE WHO WORKS 3 DAYS IN THE WEEK IN WHICH A HOLIDAY FALLS SHALL BE PAID FOR THE HOLIDAY.) (HAZMAT WORK: \$2.00 PER HOUR ADDITIONAL. TUNNEL/SHAFT WORK: \$5.00 PER HOUR ADDITIONAL.)

.....\$ 48.57	29.95
POWER EQUIPMENT OPERATOR: BUILDING CONSTRUCTION:	
GROUP 3: TELEHANDLER EQUIPMENT, FORKLIFT, CONCRETE	
PUMP & ON-SITE CONCRETE PLANT. (BOOM LENGTHS,	
INCLUDING JIBS: 150 FT. AND OVER: + \$ 2.00; 180	
FT. AND OVER: + \$ 3.00; 210 FT. AND OVER: + \$	
4.00; 240 FT. AND OVER: + \$ 5.00; 270 FT. AND	
OVER: + \$ 7.00; 300 FT. AND OVER: + \$ 8.00; 350	
FT. AND OVER: + \$ 9.00; 400 FT. AND OVER: +	
\$10.00) (PAID HOLIDAYS: NEW YEAR'S DAY, PRESIDENT'S	
DAY, MEMORIAL DAY, JULY FOURTH, VICTORY DAY, LABOR	
DAY, COLUMBUS DAY, VETERANS DAY, THANKSGIVING DAY &	
CHRISTMAS DAY. A: ANY EMPLOYEE WHO WORKS 3 DAYS IN	
THE WEEK IN WHICH A HOLIDAY FALLS SHALL BE PAID FOR	
THE HOLIDAY.) (HAZMAT WORK: \$2.00 PER HOUR	
ADDITIONAL. TUNNEL/SHAFT WORK: \$5.00 PER HOUR	
ADDITIONAL.).....\$ 48.35	29.95
POWER EQUIPMENT OPERATOR: BUILDING CONSTRUCTION:	
GROUP 4: FIREMAN & OILER ON CRANES. (BOOM LENGTHS,	
INCLUDING JIBS: 150 FT. AND OVER: + \$ 2.00; 180	
FT. AND OVER: + \$ 3.00; 210 FT. AND OVER: + \$	
4.00; 240 FT. AND OVER: + \$ 5.00; 270 FT. AND	
OVER: + \$ 7.00; 300 FT. AND OVER: + \$ 8.00; 350	
FT. AND OVER: + \$ 9.00; 400 FT. AND OVER: +	
\$10.00) (PAID HOLIDAYS: NEW YEAR'S DAY, PRESIDENT'S	
DAY, MEMORIAL DAY, JULY FOURTH, VICTORY DAY, LABOR	
DAY, COLUMBUS DAY, VETERANS DAY, THANKSGIVING DAY &	
CHRISTMAS DAY. A: ANY EMPLOYEE WHO WORKS 3 DAYS IN	
THE WEEK IN WHICH A HOLIDAY FALLS SHALL BE PAID FOR	
THE HOLIDAY.) (HAZMAT WORK: \$2.00 PER HOUR	
ADDITIONAL. TUNNEL/SHAFT WORK: \$5.00 PER HOUR	
ADDITIONAL.).....\$ 44.35	29.95
POWER EQUIPMENT OPERATOR: BUILDING CONSTRUCTION:	
GROUP 5: OILER ON CRAWLER BACKHOE. (BOOM LENGTHS,	
INCLUDING JIBS: 150 FT. AND OVER: + \$ 2.00; 180	
FT. AND OVER: + \$ 3.00; 210 FT. AND OVER: + \$	
4.00; 240 FT. AND OVER: + \$ 5.00; 270 FT. AND	
OVER: + \$ 7.00; 300 FT. AND OVER: + \$ 8.00; 350	
FT. AND OVER: + \$ 9.00; 400 FT. AND OVER: +	
\$10.00) (PAID HOLIDAYS: NEW YEAR'S DAY, PRESIDENT'S	
DAY, MEMORIAL DAY, JULY FOURTH, VICTORY DAY, LABOR	
DAY, COLUMBUS DAY, VETERANS DAY, THANKSGIVING DAY &	
CHRISTMAS DAY. A: ANY EMPLOYEE WHO WORKS 3 DAYS IN	
THE WEEK IN WHICH A HOLIDAY FALLS SHALL BE PAID FOR	
THE HOLIDAY.) (HAZMAT WORK: \$2.00 PER HOUR	
ADDITIONAL. TUNNEL/SHAFT WORK: \$5.00 PER HOUR	
ADDITIONAL.).....\$ 41.50	29.95
POWER EQUIPMENT OPERATOR: BUILDING CONSTRUCTION:	
GROUP 6: BULLDOZER, SKID STEER LOADERS, BOBCATS,	
TRACTOR, GRADER, SCRAPER, COMBINATION LOADER	
BACKHOE, ROLLER, FRONT END LOADER (LESS THAN 3	
YDS.), STREET AND MOBILE POWERED SWEEPER (3 YDS.	
CAPACITY), 8-FT. SWEEPER (MINIMUM 65 HP). (BOOM	
LENGTHS, INCLUDING JIBS: 150 FT. AND OVER: + \$	
2.00; 180 FT. AND OVER: + \$ 3.00; 210 FT. AND	
OVER: + \$ 4.00; 240 FT. AND OVER: + \$ 5.00; 270	
FT. AND OVER: + \$ 7.00; 300 FT. AND OVER: + \$	
8.00; 350 FT. AND OVER: + \$ 9.00; 400 FT. AND	
OVER: + \$10.00) (PAID HOLIDAYS: NEW YEAR'S DAY,	
PRESIDENT'S DAY, MEMORIAL DAY, JULY FOURTH, VICTORY	
DAY, LABOR DAY, COLUMBUS DAY, VETERANS DAY,	
THANKSGIVING DAY & CHRISTMAS DAY. A: ANY EMPLOYEE	
WHO WORKS 3 DAYS IN THE WEEK IN WHICH A HOLIDAY	
FALLS SHALL BE PAID FOR THE HOLIDAY.) (HAZMAT WORK:	
\$2.00 PER HOUR ADDITIONAL. TUNNEL/SHAFT WORK: \$5.00	
PER HOUR ADDITIONAL.).....\$ 47.65	29.95

POWER EQUIPMENT OPERATOR: BUILDING CONSTRUCTION:
 GROUP 7: WELL POINT INSTALLATION CREW. (BOOM
 LENGTHS, INCLUDING JIBS: 150 FT. AND OVER: + \$
 2.00; 180 FT. AND OVER: + \$ 3.00; 210 FT. AND
 OVER: + \$ 4.00; 240 FT. AND OVER: + \$ 5.00; 270
 FT. AND OVER: + \$ 7.00; 300 FT. AND OVER: + \$
 8.00; 350 FT. AND OVER: + \$ 9.00; 400 FT. AND
 OVER: + \$10.00) (PAID HOLIDAYS: NEW YEAR'S DAY,
 PRESIDENT'S DAY, MEMORIAL DAY, JULY FOURTH, VICTORY
 DAY, LABOR DAY, COLUMBUS DAY, VETERANS DAY,
 THANKSGIVING DAY & CHRISTMAS DAY. A: ANY EMPLOYEE
 WHO WORKS 3 DAYS IN THE WEEK IN WHICH A HOLIDAY
 FALLS SHALL BE PAID FOR THE HOLIDAY.) (HAZMAT WORK:
 \$2.00 PER HOUR ADDITIONAL. TUNNEL/SHAFT WORK: \$5.00
 PER HOUR ADDITIONAL.).....\$ 47.22 29.95

POWER EQUIPMENT OPERATOR: BUILDING CONSTRUCTION:
 GROUP 8: HEATER, CONCRETE MIXER, STONE CRUSHER,
 WELDING MACHINE, GENERATOR FOR LIGHT PLANT, GAS AND
 ELECTRIC DRIVEN PUMP & AIR COMPRESSOR. (BOOM
 LENGTHS, INCLUDING JIBS: 150 FT. AND OVER: + \$
 2.00; 180 FT. AND OVER: + \$ 3.00; 210 FT. AND
 OVER: + \$ 4.00; 240 FT. AND OVER: + \$ 5.00; 270
 FT. AND OVER: + \$ 7.00; 300 FT. AND OVER: + \$
 8.00; 350 FT. AND OVER: + \$ 9.00; 400 FT. AND
 OVER: + \$10.00) (PAID HOLIDAYS: NEW YEAR'S DAY,
 PRESIDENT'S DAY, MEMORIAL DAY, JULY FOURTH, VICTORY
 DAY, LABOR DAY, COLUMBUS DAY, VETERANS DAY,
 THANKSGIVING DAY & CHRISTMAS DAY. A: ANY EMPLOYEE
 WHO WORKS 3 DAYS IN THE WEEK IN WHICH A HOLIDAY
 FALLS SHALL BE PAID FOR THE HOLIDAY.) (HAZMAT WORK:
 \$2.00 PER HOUR ADDITIONAL. TUNNEL/SHAFT WORK: \$5.00
 PER HOUR ADDITIONAL.).....\$ 44.54 29.95

ENGI0057-005 12/01/2025

Rates

Fringes

POWER EQUIPMENT OPERATOR: HIGHWAY CONSTRUCTION
 PROJECTS; WATER AND SEWERLINE PROJECTS WHICH ARE
 INCIDENTAL TO HIGHWAY CONSTRUCTION PROJECTS; AND
 BRIDGE PROJECTS THAT DO NOT SPAN WATER: GROUP 1:
 CRANES, PILE DRIVERS, LIGHTERS, BOOM TRUCKS,
 HOISTS, DERRICKS. (ANY EMPLOYEE WHO WORKS THREE
 DAYS IN THE WEEK IN WHICH A HOLIDAY FALLS SHALL BE
 PAID FOR THE HOLIDAY. PAID HOLIDAYS: NEW YEAR'S
 DAY, PRESIDENT'S DAY, MEMORIAL DAY, JULY FOURTH,
 VICTORY DAY, LABOR DAY, COLUMBUS DAY, VETERANS DAY,
 THANKSGIVING DAY & CHRISTMAS DAY.).....\$ 46.45 29.95

POWER EQUIPMENT OPERATOR: HIGHWAY CONSTRUCTION
 PROJECTS; WATER AND SEWERLINE PROJECTS WHICH ARE
 INCIDENTAL TO HIGHWAY CONSTRUCTION PROJECTS; AND
 BRIDGE PROJECTS THAT DO NOT SPAN WATER: GROUP 2:
 DIGGING MACHINES, EXCAVATORS, LOCOMOTIVES, JOHN
 HENRY'S, DIRECTIONAL DRILLING MACHINES, COLD
 PLANERS, RECLAIMERS, PAVERS, SPREADERS, GRADERS,
 FRONT-END LOADERS (3YDS & OVER), VACUUM TRUCK,
 DRILL/BORING MACHINE OPERATORS, VERMEER SAW, WATER
 BLASTER, HYDRAULIC-DEMOLITION ROBOT, ROSS CARRIERS,
 CONCRETE PUMP OPERATORS, ASPHALT/MATERIAL TRANSFER
 MACHINES, ROTATING TELEHANDLERS, SPMT TYPE
 EQUIPMENT. (ANY EMPLOYEE WHO WORKS THREE DAYS IN
 THE WEEK IN WHICH A HOLIDAY FALLS SHALL BE PAID FOR
 THE HOLIDAY. PAID HOLIDAYS: NEW YEAR'S DAY,
 PRESIDENT'S DAY, MEMORIAL DAY, JULY FOURTH, VICTORY
 DAY, LABOR DAY, COLUMBUS DAY, VETERANS DAY,
 THANKSGIVING DAY & CHRISTMAS DAY.) DAY, PRESIDENT'S
 DAY, MEMORIAL DAY, JULY FOURTH, VICTORY DAY, LABOR
 DAY, COLUMBUS DAY, VETERANS DAY, THANKSGIVING DAY &
 CHRISTMAS DAY.....\$ 44.45 29.95

POWER EQUIPMENT OPERATOR: HIGHWAY CONSTRUCTION
 PROJECTS; WATER AND SEWERLINE PROJECTS WHICH ARE

INCIDENTAL TO HIGHWAY CONSTRUCTION PROJECTS; AND
 BRIDGE PROJECTS THAT DO NOT SPAN WATER: GROUP 3:
 WELLPOINT INSTALLATION AND DRILL/BORING MACHINE
 ASSISTANTS. (ANY EMPLOYEE WHO WORKS THREE DAYS IN
 THE WEEK IN WHICH A HOLIDAY FALLS SHALL BE PAID FOR
 THE HOLIDAY. PAID HOLIDAYS: NEW YEAR'S DAY,
 PRESIDENT'S DAY, MEMORIAL DAY, JULY FOURTH, VICTORY
 DAY, LABOR DAY, COLUMBUS DAY, VETERANS DAY,
 THANKSGIVING DAY & CHRISTMAS DAY.).....\$ 39.15 29.95
 POWER EQUIPMENT OPERATOR: HIGHWAY CONSTRUCTION
 PROJECTS; WATER AND SEWERLINE PROJECTS WHICH ARE
 INCIDENTAL TO HIGHWAY CONSTRUCTION PROJECTS; AND
 BRIDGE PROJECTS THAT DO NOT SPAN WATER: GROUP 4:
 UTILITY ENGINEERS. (ANY EMPLOYEE WHO WORKS THREE
 DAYS IN THE WEEK IN WHICH A HOLIDAY FALLS SHALL BE
 PAID FOR THE HOLIDAY. PAID HOLIDAYS: NEW YEAR'S
 DAY, PRESIDENT'S DAY, MEMORIAL DAY, JULY FOURTH,
 VICTORY DAY, LABOR DAY, COLUMBUS DAY, VETERANS DAY,
 THANKSGIVING DAY & CHRISTMAS DAY.).....\$ 25.75 29.95
 POWER EQUIPMENT OPERATOR: HIGHWAY CONSTRUCTION
 PROJECTS; WATER AND SEWERLINE PROJECTS WHICH ARE
 INCIDENTAL TO HIGHWAY CONSTRUCTION PROJECTS; AND
 BRIDGE PROJECTS THAT DO NOT SPAN WATER: GROUP 5:
 SIGNAL PERSONS. (ANY EMPLOYEE WHO WORKS THREE DAYS
 IN THE WEEK IN WHICH A HOLIDAY FALLS SHALL BE PAID
 FOR THE HOLIDAY. PAID HOLIDAYS: NEW YEAR'S DAY,
 PRESIDENT'S DAY, MEMORIAL DAY, JULY FOURTH, VICTORY
 DAY, LABOR DAY, COLUMBUS DAY, VETERANS DAY,
 THANKSGIVING DAY & CHRISTMAS DAY.).....\$ 33.15 29.95
 POWER EQUIPMENT OPERATOR: HIGHWAY CONSTRUCTION
 PROJECTS; WATER AND SEWERLINE PROJECTS WHICH ARE
 INCIDENTAL TO HIGHWAY CONSTRUCTION PROJECTS; AND
 BRIDGE PROJECTS THAT DO NOT SPAN WATER: GROUP 6:
 OILERS ON CRANES AND DECKHANDS. (ANY EMPLOYEE WHO
 WORKS THREE DAYS IN THE WEEK IN WHICH A HOLIDAY
 FALLS SHALL BE PAID FOR THE HOLIDAY. PAID
 HOLIDAYS: NEW YEAR'S DAY, PRESIDENT'S DAY, MEMORIAL
 DAY, JULY FOURTH, VICTORY DAY, LABOR DAY, COLUMBUS
 DAY, VETERANS DAY, THANKSGIVING DAY & CHRISTMAS
 DAY.).....\$ 39.73 29.95
 POWER EQUIPMENT OPERATOR: HIGHWAY CONSTRUCTION
 PROJECTS; WATER AND SEWERLINE PROJECTS WHICH ARE
 INCIDENTAL TO HIGHWAY CONSTRUCTION PROJECTS; AND
 BRIDGE PROJECTS THAT DO NOT SPAN WATER: GROUP 7:
 COMBINATION LOADER / BACKHOES, FRONT-END LOADERS
 (LESS THAN 3 YDS.), FORKLIFT, BULLDOZERS, SCRAPERS,
 BOATS, ROLLERS, SKID STEER LOADERS (REGARDLESS OF
 ATTACHMENTS), STREET SWEEPERS, MECHANICS, WELDERS,
 OPERATORS IN MATERIALS YARDS, SHOPS AND GARAGES.
 (ANY EMPLOYEE WHO WORKS THREE DAYS IN THE WEEK IN
 WHICH A HOLIDAY FALLS SHALL BE PAID FOR THE
 HOLIDAY. PAID HOLIDAYS: NEW YEAR'S DAY,
 PRESIDENT'S DAY, MEMORIAL DAY, JULY FOURTH, VICTORY
 DAY, LABOR DAY, COLUMBUS DAY, VETERANS DAY,
 THANKSGIVING DAY & CHRISTMAS DAY.).....\$ 43.43 29.95
 POWER EQUIPMENT OPERATOR: HIGHWAY CONSTRUCTION
 PROJECTS; WATER AND SEWERLINE PROJECTS WHICH ARE
 INCIDENTAL TO HIGHWAY CONSTRUCTION PROJECTS; AND
 BRIDGE PROJECTS THAT DO NOT SPAN WATER: GROUP 8:
 GAS AND ELECTRIC DRIVE HEATERS, CONCRETE MIXERS,
 LIGHT PLANTS, WELDING MACHINES, PUMPS AND
 COMPRESSORS. (ANY EMPLOYEE WHO WORKS THREE DAYS IN
 THE WEEK IN WHICH A HOLIDAY FALLS SHALL BE PAID FOR
 THE HOLIDAY. PAID HOLIDAYS: NEW YEAR'S DAY,
 PRESIDENT'S DAY, MEMORIAL DAY, JULY FOURTH, VICTORY
 DAY, LABOR DAY, COLUMBUS DAY, VETERANS DAY,
 THANKSGIVING DAY & CHRISTMAS DAY.).....\$ 38.70 29.95

	Rates	Fringes
IRONWORKER.....	\$ 43.03	33.53

LAB00271-001 12/03/2023

	Rates	Fringes
LABORER (BUILDING CONSTRUCTION): GROUP 1: Laborer, Carpenter Tender, Mason Tender, Cement Finisher Tender, Scaffold Erector, Wrecking Laborer, Asbestos Removal [Non-Mechanical Systems].....	\$ 37.00	26.90
LABORER (BUILDING CONSTRUCTION): GROUP 2: Asphalt Raker, Adzemen, Pipe Trench Bracer, Demolition Burner, Chain Saw Operator, Fence & Guard Rail Erector, Setter of Metal Forms for Roadways, Mortar Mixer, Pipelayer, Riprap & Dry Stonewall Builder, Highway Stone Spreader, Pneumatic Tool Operator, Wagon Drill Operator, Tree Trimmer, Barco-Type Jumping Tamper, Mechanical Grinder Operator.....	\$ 37.00	26.90
LABORER (BUILDING CONSTRUCTION): GROUP 3: Pre-Cast Floor & Roof Plank Erectors.....	\$ 37.00	26.90
LABORER (BUILDING CONSTRUCTION): GROUP 4: Air Track Operator, Hydraulic & Similar Self-Powered Drill, Block Paver, Rammer, Curb Setter, Powderman & Blaster.....	\$ 37.00	26.90
LABORER (BUILDING CONSTRUCTION): GROUP 5: Toxic Waste Remover.....	\$ 39.00	26.90

LAB00271-002 11/27/2022

	Rates	Fringes
LABORER (HEAVY AND HIGHWAY CONSTRUCTION): COMPRESSED AIR: GROUP 1: Mucking machine operator, tunnel laborer, brake person, track person, miner, grout person, lock tender, gauge tender, miner: motor person & all others in compressed air	\$ 55.40	24.15
LABORER (HEAVY AND HIGHWAY CONSTRUCTION): COMPRESSED AIR: GROUP 2: Change house attendant, powder watchperson, top person on iron	\$ 52.93	24.15
LABORER (HEAVY AND HIGHWAY CONSTRUCTION): COMPRESSED AIR: GROUP 3: Hazardous waste work within the "HOT" zone.....	\$ 42.45	24.15
LABORER (HEAVY AND HIGHWAY CONSTRUCTION): FREE AIR: GROUP 1: Grout person - pumps, brake person, track person, form mover & stripper (wood & steel), shaft laborer, laborer topside, outside motorperson, miner, conveyor operator, miner welder, heading motorperson, erecting operator, mucking machine operator, nozzle person, rodperson, safety miner, shaft & tunnel, steel & rodperson, mole nipper, concrete worker, form erector (wood, steel and all accessories), cement finisher (this type of work only), top signal person, bottom person (when heading is 50' from shaft), burner, shield operator and TBM operator.....	\$ 46.00	24.15
LABORER (HEAVY AND HIGHWAY CONSTRUCTION): FREE AIR: GROUP 2: Change house attendant, powder watchperson	\$ 45.00	24.15
LABORER (HEAVY AND HIGHWAY CONSTRUCTION): FREE AIR: GROUP 3: Hazardous waste work within the "HOT" zone.	\$ 42.45	24.15
LABORER (HEAVY AND HIGHWAY CONSTRUCTION): GROUP 1: Laborer; Carpenter tender; Cement finisher tender; Wrecking laborer; Asbestos removers [non-mechanical systems]; Plant laborer; Driller in quarries.....	\$ 33.05	24.05
LABORER (HEAVY AND HIGHWAY CONSTRUCTION): GROUP 2: Adzeperson; Asphalt raker; Barcotype jumping tamper; Chain saw operators; Concrete and power buggy operator; Concrete saw operator; Demolition burner; Fence and guard rail erector; Highway stone spreader; Laser beam operator; Mechanical grinder operator; Mason tender; Mortar mixer; Pneumatic tool operator; Riprap and dry stonewall builder;		

Scaffold erector; Setter of metal forms for roadways; Wagon drill operator; Wood chipper operator; Pipelayer; Pipe trench bracer	\$ 35.75	24.85
LABORER (HEAVY AND HIGHWAY CONSTRUCTION): GROUP 3: Air track drill operator; Hydraulic and similar powered drills; Brick paver; Block paver; Rammer and curb setter; Powderperson and blaster.....	\$ 36.50	24.85
LABORER (HEAVY AND HIGHWAY CONSTRUCTION): GROUP 4: Flagger & signaler.....	\$ 29.00	24.85
LABORER (HEAVY AND HIGHWAY CONSTRUCTION): GROUP 5: Toxic waste remover	\$ 33.05	24.05
LABORER (HEAVY AND HIGHWAY CONSTRUCTION): OPEN AIR CAISSON, UNDERPINNING WORK AND BORING CREW: BOTTOM MAN.....	\$ 41.50	24.15
LABORER (HEAVY AND HIGHWAY CONSTRUCTION): OPEN AIR CAISSON, UNDERPINNING WORK AND BORING CREW: TOP MAN & LABORER.....	\$ 35.60	24.15
LABORER (HEAVY AND HIGHWAY CONSTRUCTION): TEST BORING: DRILLER.....	\$ 41.95	24.15
LABORER (HEAVY AND HIGHWAY CONSTRUCTION): TEST BORING: LABORER.....	\$ 41.95	24.15

PAIN0011-005 06/01/2025		
	Rates	Fringes
PAINTER (BRUSH AND ROLLER).....	\$ 39.57	26.60
PAINTER (EPOXY, TANKS, TOWERS, SWING STAGE & STRUCTURAL STEEL).....	\$ 41.57	26.60
PAINTER (SPRAY, SAND & WATER BLASTING).....	\$ 42.57	26.60
PAINTER (TAPER).....	\$ 38.82	25.80
PAINTER (WALL COVERER).....	\$ 38.57	25.80

PAIN0011-006 06/01/2024		
	Rates	Fringes
GLAZIER (SWING STAGE: \$1.00 PER HOUR ADDITIONAL. PAID HOLIDAYS: LABOR DAY & CHRISTMAS DAY.).....	\$ 41.63	26.15

PAIN0011-011 06/01/2024		
	Rates	Fringes
PAINTER (BRIDGE WORK).....	\$ 57.85	26.40

PAIN0035-008 06/01/2011		
	Rates	Fringes
SIGN PAINTER.....	\$ 24.79	13.72

PLAS0040-001 01/01/2025		
	Rates	Fringes
CEMENT MASON/CONCRETE FINISHER (BUILDING CONSTRUCTION) (CEMENT MASON: WORK ON FREE SWINGING SCAFFOLDS UNDER 3 PLANKS WIDTH AND WHICH IS 20 OR MORE FEET ABOVE GROUND AND ANY OFFSET STRUCTURE: \$.30 PER HOUR ADDITIONAL.).....	\$ 44.75	29.10

PLAS0040-002 01/01/2025		
	Rates	Fringes
CEMENT MASON/CONCRETE FINISHER (HEAVY AND HIGHWAY CONSTRUCTION).....	\$ 40.45	25.30

PLAS0040-003 01/01/2025		
	Rates	Fringes
PLASTERER.....	\$ 45.52	29.43

PLUM0051-002 08/25/2025		
-------------------------	--	--

	Rates	Fringes
PLUMBERS AND PIPEFITTERS.....	\$ 54.34	34.50

ROOF0033-004 12/01/2025

	Rates	Fringes
ROOFER.....	\$ 47.49	31.44

SFRI0669-001 04/01/2025

	Rates	Fringes
SPRINKLER FITTER.....	\$ 53.76	33.44

SHEE0017-002 06/01/2025

	Rates	Fringes
SHEET METAL WORKER.....	\$ 44.42	41.94

TEAM0251-001 05/01/2025

	Rates	Fringes
--	-------	---------

TRUCK DRIVER: HEAVY AND HIGHWAY CONSTRUCTION: GROUP

1: PICK-UP TRUCKS, STATION WAGONS, & PANEL TRUCKS
 (ADDITIONAL FRINGE TO BE PAID: PAID HOLIDAYS: NEW
 YEAR'S DAY, MEMORIAL DAY, INDEPENDENCE DAY, LABOR
 DAY, THANKSGIVING DAY AND CHRISTMAS DAY, PLUS
 PRESIDENTS' DAY, COLUMBUS DAY, VETERAN'S DAY & V-J
 DAY, PROVIDING THE EMPLOYEE HAS WORKED AT LEAST ONE
 DAY IN THE CALENDAR WEEK IN WHICH THE HOLIDAY
 FALLS. EMPLOYEE WHO HAS BEEN ON THE PAYROLL FOR 1
 YEAR OR MORE BUT LESS THAN 5 YEARS AND HAS WORKED
 150 DAYS DURING THE LAST YEAR OF EMPLOYMENT SHALL
 RECEIVE 1 WEEK'S PAID VACATION; 5 TO 10 YEARS - 2
 WEEKS' PAID VACATION; 10 OR MORE YEARS - 3 WEEK'S
 PAID VACATION.) (EMPLOYEES ON THE SENIORITY LIST
 SHALL BE PAID A ONE HUNDRED DOLLAR (\$100.00) BONUS
 FOR EVERY FOUR HUNDRED (400) HOURS WORKED, UP TO A
 MAXIMUM OF FIVE HUNDRED DOLLARS (\$500.00)) (ALL
 DRIVERS WORKING ON A DEFINED HAZARD MATERIAL JOB
 SITE SHALL BE PAID A PREMIUM OF \$2.00 PER HOUR OVER
 APPLICABLE RATE.)

.....	\$ 31.86	34.51
-------	----------	-------

TRUCK DRIVER: HEAVY AND HIGHWAY CONSTRUCTION: GROUP

2: TWO-AXLE ON LOW BEDS (ADDITIONAL FRINGE TO BE
 PAID: PAID HOLIDAYS: NEW YEAR'S DAY, MEMORIAL DAY,
 INDEPENDENCE DAY, LABOR DAY, THANKSGIVING DAY AND
 CHRISTMAS DAY, PLUS PRESIDENTS' DAY, COLUMBUS DAY,
 VETERAN'S DAY & V-J DAY, PROVIDING THE EMPLOYEE HAS
 WORKED AT LEAST ONE DAY IN THE CALENDAR WEEK IN
 WHICH THE HOLIDAY FALLS. EMPLOYEE WHO HAS BEEN ON
 THE PAYROLL FOR 1 YEAR OR MORE BUT LESS THAN 5
 YEARS AND HAS WORKED 150 DAYS DURING THE LAST YEAR
 OF EMPLOYMENT SHALL RECEIVE 1 WEEK'S PAID VACATION;
 5 TO 10 YEARS - 2 WEEKS' PAID VACATION; 10 OR MORE
 YEARS - 3 WEEK'S PAID VACATION.) (EMPLOYEES ON THE
 SENIORITY LIST SHALL BE PAID A ONE HUNDRED DOLLAR
 (\$100.00) BONUS FOR EVERY FOUR HUNDRED (400) HOURS
 WORKED, UP TO A MAXIMUM OF FIVE HUNDRED DOLLARS
 (\$500.00)) (ALL DRIVERS WORKING ON A DEFINED HAZARD
 MATERIAL JOB SITE SHALL BE PAID A PREMIUM OF \$2.00
 PER HOUR OVER APPLICABLE RATE.)

.....	\$ 32.01	34.51
-------	----------	-------

TRUCK DRIVER: HEAVY AND HIGHWAY CONSTRUCTION: GROUP

3: TWO-AXLE DUMP TRUCK (ADDITIONAL FRINGE TO BE
 PAID: PAID HOLIDAYS: NEW YEAR'S DAY, MEMORIAL DAY,
 INDEPENDENCE DAY, LABOR DAY, THANKSGIVING DAY AND
 CHRISTMAS DAY, PLUS PRESIDENTS' DAY, COLUMBUS DAY,
 VETERAN'S DAY & V-J DAY, PROVIDING THE EMPLOYEE HAS
 WORKED AT LEAST ONE DAY IN THE CALENDAR WEEK IN
 WHICH THE HOLIDAY FALLS. EMPLOYEE WHO HAS BEEN ON
 THE PAYROLL FOR 1 YEAR OR MORE BUT LESS THAN 5
 YEARS AND HAS WORKED 150 DAYS DURING THE LAST YEAR

OF EMPLOYMENT SHALL RECEIVE 1 WEEK'S PAID VACATION;
 5 TO 10 YEARS - 2 WEEKS' PAID VACATION; 10 OR MORE
 YEARS - 3 WEEK'S PAID VACATION.) (EMPLOYEES ON THE
 SENIORITY LIST SHALL BE PAID A ONE HUNDRED DOLLAR
 (\$100.00) BONUS FOR EVERY FOUR HUNDRED (400) HOURS
 WORKED, UP TO A MAXIMUM OF FIVE HUNDRED DOLLARS
 (\$500.00)) (ALL DRIVERS WORKING ON A DEFINED HAZARD
 MATERIAL JOB SITE SHALL BE PAID A PREMIUM OF \$2.00
 PER HOUR OVER APPLICABLE RATE.)\$ 32.06 34.51

TRUCK DRIVER: HEAVY AND HIGHWAY CONSTRUCTION: GROUP
 4: THREE-AXLE DUMP TRUCK (ADDITIONAL FRINGE TO BE
 PAID: PAID HOLIDAYS: NEW YEAR'S DAY, MEMORIAL DAY,
 INDEPENDENCE DAY, LABOR DAY, THANKSGIVING DAY AND
 CHRISTMAS DAY, PLUS PRESIDENTS' DAY, COLUMBUS DAY,
 VETERAN'S DAY & V-J DAY, PROVIDING THE EMPLOYEE HAS
 WORKED AT LEAST ONE DAY IN THE CALENDAR WEEK IN
 WHICH THE HOLIDAY FALLS. EMPLOYEE WHO HAS BEEN ON
 THE PAYROLL FOR 1 YEAR OR MORE BUT LESS THAN 5
 YEARS AND HAS WORKED 150 DAYS DURING THE LAST YEAR
 OF EMPLOYMENT SHALL RECEIVE 1 WEEK'S PAID VACATION;
 5 TO 10 YEARS - 2 WEEKS' PAID VACATION; 10 OR MORE
 YEARS - 3 WEEK'S PAID VACATION.) (EMPLOYEES ON THE
 SENIORITY LIST SHALL BE PAID A ONE HUNDRED DOLLAR
 (\$100.00) BONUS FOR EVERY FOUR HUNDRED (400) HOURS
 WORKED, UP TO A MAXIMUM OF FIVE HUNDRED DOLLARS
 (\$500.00)) (ALL DRIVERS WORKING ON A DEFINED HAZARD
 MATERIAL JOB SITE SHALL BE PAID A PREMIUM OF \$2.00
 PER HOUR OVER APPLICABLE RATE.)\$ 32.11 34.51

TRUCK DRIVER: HEAVY AND HIGHWAY CONSTRUCTION: GROUP
 5: FOUR- AND FIVE-AXLE EQUIPMENT. (ADDITIONAL
 FRINGE TO BE PAID: PAID HOLIDAYS: NEW YEAR'S DAY,
 MEMORIAL DAY, INDEPENDENCE DAY, LABOR DAY,
 THANKSGIVING DAY AND CHRISTMAS DAY, PLUS
 PRESIDENTS' DAY, COLUMBUS DAY, VETERAN'S DAY & V-J
 DAY, PROVIDING THE EMPLOYEE HAS WORKED AT LEAST ONE
 DAY IN THE CALENDAR WEEK IN WHICH THE HOLIDAY
 FALLS. EMPLOYEE WHO HAS BEEN ON THE PAYROLL FOR 1
 YEAR OR MORE BUT LESS THAN 5 YEARS AND HAS WORKED
 150 DAYS DURING THE LAST YEAR OF EMPLOYMENT SHALL
 RECEIVE 1 WEEK'S PAID VACATION; 5 TO 10 YEARS - 2
 WEEKS' PAID VACATION; 10 OR MORE YEARS - 3 WEEK'S
 PAID VACATION.) (EMPLOYEES ON THE SENIORITY LIST
 SHALL BE PAID A ONE HUNDRED DOLLAR (\$100.00) BONUS
 FOR EVERY FOUR HUNDRED (400) HOURS WORKED, UP TO A
 MAXIMUM OF FIVE HUNDRED DOLLARS (\$500.00)) (ALL
 DRIVERS WORKING ON A DEFINED HAZARD MATERIAL JOB
 SITE SHALL BE PAID A PREMIUM OF \$2.00 PER HOUR OVER
 APPLICABLE RATE.)\$ 32.21 34.51

TRUCK DRIVER: HEAVY AND HIGHWAY CONSTRUCTION: GROUP
 6: LOW-BED OR BOOM TRAILER. (ADDITIONAL FRINGE TO
 BE PAID: PAID HOLIDAYS: NEW YEAR'S DAY, MEMORIAL
 DAY, INDEPENDENCE DAY, LABOR DAY, THANKSGIVING DAY
 AND CHRISTMAS DAY, PLUS PRESIDENTS' DAY, COLUMBUS
 DAY, VETERAN'S DAY & V-J DAY, PROVIDING THE
 EMPLOYEE HAS WORKED AT LEAST ONE DAY IN THE
 CALENDAR WEEK IN WHICH THE HOLIDAY FALLS. EMPLOYEE
 WHO HAS BEEN ON THE PAYROLL FOR 1 YEAR OR MORE BUT
 LESS THAN 5 YEARS AND HAS WORKED 150 DAYS DURING
 THE LAST YEAR OF EMPLOYMENT SHALL RECEIVE 1 WEEK'S
 PAID VACATION; 5 TO 10 YEARS - 2 WEEKS' PAID
 VACATION; 10 OR MORE YEARS - 3 WEEK'S PAID
 VACATION.) (EMPLOYEES ON THE SENIORITY LIST SHALL
 BE PAID A ONE HUNDRED DOLLAR (\$100.00) BONUS FOR
 EVERY FOUR HUNDRED (400) HOURS WORKED, UP TO A
 MAXIMUM OF FIVE HUNDRED DOLLARS (\$500.00)) (ALL
 DRIVERS WORKING ON A DEFINED HAZARD MATERIAL JOB
 SITE SHALL BE PAID A PREMIUM OF \$2.00 PER HOUR OVER
 APPLICABLE RATE.)\$ 32.61 34.51

TRUCK DRIVER: HEAVY AND HIGHWAY CONSTRUCTION: GROUP
 7: TRAILERS WHEN USED ON A DOUBLE HOOK UP (PULLING

2 TRAILERS). (ADDITIONAL FRINGE TO BE PAID: PAID HOLIDAYS: NEW YEAR'S DAY, MEMORIAL DAY, INDEPENDENCE DAY, LABOR DAY, THANKSGIVING DAY AND CHRISTMAS DAY, PLUS PRESIDENTS' DAY, COLUMBUS DAY, VETERAN'S DAY & V-J DAY, PROVIDING THE EMPLOYEE HAS WORKED AT LEAST ONE DAY IN THE CALENDAR WEEK IN WHICH THE HOLIDAY FALLS. EMPLOYEE WHO HAS BEEN ON THE PAYROLL FOR 1 YEAR OR MORE BUT LESS THAN 5 YEARS AND HAS WORKED 150 DAYS DURING THE LAST YEAR OF EMPLOYMENT SHALL RECEIVE 1 WEEK'S PAID VACATION; 5 TO 10 YEARS - 2 WEEKS' PAID VACATION; 10 OR MORE YEARS - 3 WEEK'S PAID VACATION.) (EMPLOYEES ON THE SENIORITY LIST SHALL BE PAID A ONE HUNDRED DOLLAR (\$100.00) BONUS FOR EVERY FOUR HUNDRED (400) HOURS WORKED, UP TO A MAXIMUM OF FIVE HUNDRED DOLLARS (\$500.00)) (ALL DRIVERS WORKING ON A DEFINED HAZARD MATERIAL JOB SITE SHALL BE PAID A PREMIUM OF \$2.00 PER HOUR OVER APPLICABLE RATE.)

.....\$ 32.81

34.51

TRUCK DRIVER: HEAVY AND HIGHWAY CONSTRUCTION: GROUP 8: SPECIAL EARTH-MOVING EQUIPMENT, UNDER 35 TONS. (ADDITIONAL FRINGE TO BE PAID: PAID HOLIDAYS: NEW YEAR'S DAY, MEMORIAL DAY, INDEPENDENCE DAY, LABOR DAY, THANKSGIVING DAY AND CHRISTMAS DAY, PLUS PRESIDENTS' DAY, COLUMBUS DAY, VETERAN'S DAY & V-J DAY, PROVIDING THE EMPLOYEE HAS WORKED AT LEAST ONE DAY IN THE CALENDAR WEEK IN WHICH THE HOLIDAY FALLS. EMPLOYEE WHO HAS BEEN ON THE PAYROLL FOR 1 YEAR OR MORE BUT LESS THAN 5 YEARS AND HAS WORKED 150 DAYS DURING THE LAST YEAR OF EMPLOYMENT SHALL RECEIVE 1 WEEK'S PAID VACATION; 5 TO 10 YEARS - 2 WEEKS' PAID VACATION; 10 OR MORE YEARS - 3 WEEK'S PAID VACATION.) (EMPLOYEES ON THE SENIORITY LIST SHALL BE PAID A ONE HUNDRED DOLLAR (\$100.00) BONUS FOR EVERY FOUR HUNDRED (400) HOURS WORKED, UP TO A MAXIMUM OF FIVE HUNDRED DOLLARS (\$500.00)) (ALL DRIVERS WORKING ON A DEFINED HAZARD MATERIAL JOB SITE SHALL BE PAID A PREMIUM OF \$2.00 PER HOUR OVER APPLICABLE RATE.)

.....\$ 32.31

34.51

TRUCK DRIVER: HEAVY AND HIGHWAY CONSTRUCTION: GROUP 9: SPECIAL EARTH-MOVING EQUIPMENT, 35 TONS OR OVER. (ADDITIONAL FRINGE TO BE PAID: PAID HOLIDAYS: NEW YEAR'S DAY, MEMORIAL DAY, INDEPENDENCE DAY, LABOR DAY, THANKSGIVING DAY AND CHRISTMAS DAY, PLUS PRESIDENTS' DAY, COLUMBUS DAY, VETERAN'S DAY & V-J DAY, PROVIDING THE EMPLOYEE HAS WORKED AT LEAST ONE DAY IN THE CALENDAR WEEK IN WHICH THE HOLIDAY FALLS. EMPLOYEE WHO HAS BEEN ON THE PAYROLL FOR 1 YEAR OR MORE BUT LESS THAN 5 YEARS AND HAS WORKED 150 DAYS DURING THE LAST YEAR OF EMPLOYMENT SHALL RECEIVE 1 WEEK'S PAID VACATION; 5 TO 10 YEARS - 2 WEEKS' PAID VACATION; 10 OR MORE YEARS - 3 WEEK'S PAID VACATION.) (EMPLOYEES ON THE SENIORITY LIST SHALL BE PAID A ONE HUNDRED DOLLAR (\$100.00) BONUS FOR EVERY FOUR HUNDRED (400) HOURS WORKED, UP TO A MAXIMUM OF FIVE HUNDRED DOLLARS (\$500.00)) (ALL DRIVERS WORKING ON A DEFINED HAZARD MATERIAL JOB SITE SHALL BE PAID A PREMIUM OF \$2.00 PER HOUR OVER APPLICABLE RATE.)

.....\$ 32.56

34.51

TRUCK DRIVER: HEAVY AND HIGHWAY CONSTRUCTION: GROUP 10: TRACTOR TRAILER. (ADDITIONAL FRINGE TO BE PAID: PAID HOLIDAYS: NEW YEAR'S DAY, MEMORIAL DAY, INDEPENDENCE DAY, LABOR DAY, THANKSGIVING DAY AND CHRISTMAS DAY, PLUS PRESIDENTS' DAY, COLUMBUS DAY, VETERAN'S DAY & V-J DAY, PROVIDING THE EMPLOYEE HAS WORKED AT LEAST ONE DAY IN THE CALENDAR WEEK IN WHICH THE HOLIDAY FALLS. EMPLOYEE WHO HAS BEEN ON THE PAYROLL FOR 1 YEAR OR MORE BUT LESS THAN 5 YEARS AND HAS WORKED 150 DAYS DURING THE LAST YEAR OF EMPLOYMENT SHALL RECEIVE 1 WEEK'S PAID VACATION;

5 TO 10 YEARS - 2 WEEKS' PAID VACATION; 10 OR MORE YEARS - 3 WEEK'S PAID VACATION.) (EMPLOYEES ON THE SENIORITY LIST SHALL BE PAID A ONE HUNDRED DOLLAR (\$100.00) BONUS FOR EVERY FOUR HUNDRED (400) HOURS WORKED, UP TO A MAXIMUM OF FIVE HUNDRED DOLLARS (\$500.00)) (ALL DRIVERS WORKING ON A DEFINED HAZARD MATERIAL JOB SITE SHALL BE PAID A PREMIUM OF \$2.00 PER HOUR OVER APPLICABLE RATE.) ...\$ 32.36 34.51

WELDERS - Receive rate prescribed for craft performing operation to which welding is incidental.

=====

Note: Executive Order (EO) 13706, Establishing Paid Sick Leave for Federal Contractors applies to all contracts subject to the Davis-Bacon Act for which the contract is awarded (and any solicitation was issued) on or after January 1, 2017. If this contract is covered by the EO, the contractor must provide employees with 1 hour of paid sick leave for every 30 hours they work, up to 56 hours of paid sick leave each year. Employees must be permitted to use paid sick leave for their own illness, injury or other health-related needs, including preventive care; to assist a family member (or person who is like family to the employee) who is ill, injured, or has other health-related needs, including preventive care; or for reasons resulting from, or to assist a family member (or person who is like family to the employee) who is a victim of, domestic violence, sexual assault, or stalking. Additional information on contractor requirements and worker protections under the EO is available at <https://www.dol.gov/agencies/whd/government-contracts>.

Note: Executive Order 13658 generally applies to contracts subject to the Davis-Bacon Act that were awarded on or between January 1, 2015 and January 29, 2022, and that have not been renewed or extended on or after January 30, 2022. Executive Order 13658 does not apply to contracts subject only to the Davis-Bacon Related Acts regardless of when they were awarded. If a contract is subject to Executive Order 13658, the contractor must pay all covered workers at least \$13.65 per hour (or the applicable wage rate listed on this wage determination, if it is higher) for all hours spent performing on the contract from May 11, 2026, through December 31, 2026. The applicable Executive Order minimum wage rate will be adjusted annually. Additional information on contractor requirements and worker protections under Executive Order 13658 is available at www.dol.gov/whd/govcontracts.

Unlisted classifications needed for work not included within the scope of the classifications listed may be added after award only as provided in the labor standards contract clauses (29CFR 5.5 (a) (1) (iii)).

The body of each wage determination lists the classifications and wage rates that have been found to be prevailing for the type(s) of construction and geographic area covered by the wage determination. The classifications are listed in alphabetical order under rate identifiers indicating whether the particular rate is a union rate (current union negotiated rate), a survey rate, a weighted union average rate, a state adopted rate, or a supplemental classification rate.

Union Rate Identifiers

A four-letter identifier beginning with characters other than SU, UAVG, SA, or SC denotes that a union rate was prevailing for that classification in the survey. Example: PLUM0198-005 07/01/2024. PLUM is an identifier of the union whose collectively bargained rate prevailed in the survey for this classification, which in this example would be Plumbers. 0198 indicates the local union number or district council

number where applicable, i.e., Plumbers Local 0198. The next number, 005 in the example, is an internal number used in processing the wage determination. The date, 07/01/2024 in the example, is the effective date of the most current negotiated rate.

Union prevailing wage rates are updated to reflect all changes over time that are reported to WHD in the rates in the collective bargaining agreement (CBA) governing the classification.

Union Average Rate Identifiers

The UAVG identifier indicates that no single rate prevailed for those classifications, but that 100% of the data reported for the classifications reflected union rates. EXAMPLE:

UAVG-OH-0010 01/01/2024. UAVG indicates that the rate is a weighted union average rate. OH indicates the State of Ohio. The next number, 0010 in the example, is an internal number used in producing the wage determination. The date, 01/01/2024 in the example, indicates the date the wage determination was updated to reflect the most current union average rate.

A UAVG rate will be updated once a year, usually in January, to reflect a weighted average of the current rates in the collective bargaining agreements on which the rate is based.

Survey Rate Identifiers

The SU identifier indicates that either a single non-union rate prevailed (as defined in 29 CFR 1.2) for this classification in the survey or that the rate was derived by computing a weighted average rate based on all the rates reported in the survey for that classification. As a weighted average rate includes all rates reported in the survey, it may include both union and non-union rates. Example: SUFL2022-007 6/27/2024. SU indicates the rate is a single non-union prevailing rate or a weighted average of survey data for that classification. FL indicates the State of Florida. 2022 is the year of the survey on which these classifications and rates are based. The next number, 007 in the example, is an internal number used in producing the wage determination. The date, 6/27/2024 in the example, indicates the survey completion date for the classifications and rates under that identifier.

SU wage rates typically remain in effect until a new survey is conducted. However, the Wage and Hour Division (WHD) has the discretion to update such rates under 29 CFR 1.6(c)(1).

State Adopted Rate Identifiers

The SA identifier indicates that the classifications and prevailing wage rates set by a state (or local) government were adopted under 29 C.F.R. 1.3(g)-(h). Example: SAME2023-007 01/03/2024. SA reflects that the rates are state adopted. ME refers to the State of Maine. 2023 is the year during which the state completed the survey on which the listed classifications and rates are based. The next number, 007 in the example, is an internal number used in producing the wage determination. The date, 01/03/2024 in the example, reflects the date on which the classifications and rates under the SA identifier took effect under state law in the state from which the rates were adopted.

WAGE DETERMINATION APPEALS PROCESS

1) Has there been an initial decision in the matter? This can be:

- a) a survey underlying a wage determination
- b) an existing published wage determination
- c) an initial WHD letter setting forth a position on

- a wage determination matter
d) an initial conformance (additional classification and rate) determination

On survey related matters, initial contact, including requests for summaries of surveys, should be directed to the WHD Branch of Wage Surveys. Requests can be submitted via email to davisbaconinfo@dol.gov or by mail to:

Branch of Wage Surveys
Wage and Hour Division
U.S. Department of Labor
200 Constitution Avenue, N.W.
Washington, DC 20210

Regarding any other wage determination matter such as conformance decisions, requests for initial decisions should be directed to the WHD Branch of Construction Wage Determinations. Requests can be submitted via email to BCWD-Office@dol.gov or by mail to:

Branch of Construction Wage Determinations
Wage and Hour Division
U.S. Department of Labor
200 Constitution Avenue, N.W.
Washington, DC 20210

2) If an initial decision has been issued, then any interested party (those affected by the action) that disagrees with the decision can request review and reconsideration from the Wage and Hour Administrator (See 29 CFR Part 1.8 and 29 CFR Part 7). Requests for review and reconsideration can be submitted via email to dba.reconsideration@dol.gov or by mail to:

Wage and Hour Administrator
U.S. Department of Labor
200 Constitution Avenue, N.W.
Washington, DC 20210

The request should be accompanied by a full statement of the interested party's position and any information (wage payment data, project description, area practice material, etc.) that the requestor considers relevant to the issue.

3) If the decision of the Administrator is not favorable, an interested party may appeal directly to the Administrative Review Board (formerly the Wage Appeals Board). Write to:

Administrative Review Board
U.S. Department of Labor
200 Constitution Avenue, N.W.
Washington, DC 20210.

=====
END OF GENERAL DECISION

"



**BOARD OF CONTRACT AND SUPPLY
CITY OF PROVIDENCE, RHODE ISLAND**

BID PACKAGE SPECIFICATIONS

Project Description:

The focus of the improvements at Hopkins Sq. Park is to mitigate washout and erosion and provide new and improved site amenities.

BASE BID: The Base Bid scope of work for this project shall include, but not be limited to the following:

- D&I ex. Benches on new Concrete Pads
- D&I Jumbo Cobble Edging
- F&I Furnishings on Concrete Pads

ADD ALTERNATES include:

- Re-install salvaged pavers
- F&I 6" Concrete Paving
- F&I new Light pole footing

In addition to stating the Total Base Bid, the bidder shall state Unit Prices for related work listed under each bid item which represents the work items included in the Total Base Bid. The Unit Prices are quoted for computing adjustments to the Base Bid prior to Contract award, as well as during the course of construction, based upon extra work ordered by the City or for work countermanded, reduced or omitted by the City in order to stay within the Project budget.

Base Bid Items and Unit prices are to be Completed prices to be added or deducted on the basis of quantities of work involved, for each item in place in the unit indicated.

All Work Included in this Project Shall be Completed for the lump sum of:

Dollars

(\$ _____), **TOTAL BASE BID**

ALLOWANCE: \$7,500.00

BASE BID W/ ALLOWANCE: \$ _____

ABBREVIATIONS

R&S	Remove & Stockpile	EA	Each
R&D	Remove & Dispose	LF	Linear Foot
D&I	Deliver & Install, owner provided	SF	Square Foot
F&I	Furnish & Install	CY	Cubic Yard
LS	Lump Sum	TN	Ton

ADD ALTERNATES:

1. **Add Alt #1 – R&S ex. Concrete Pavers and Base; F&I 6" Concrete Paving, complete. - Per Lump Sum**

_____ **LS** \$ _____
price in writing

2. **Add Alt #2 – Remove and reinstall ex. Concrete Pavers and Base, complete. - Per Lump Sum**

_____ **LS** \$ _____
price in writing

3. **Add Alt #3 – F&I new Concrete Footing and Paving for existing Light Pole, complete. - Per Lump Sum**

_____ **LS** \$ _____
price in writing

UNIT PRICES – BASE BID:

1. **F&I Temporary Tree Protection, complete. – Per Linear Foot**

_____ **LF** \$ _____
price in writing

2. **F&I Silt Sock, complete. – Per Linear Foot**

_____ **LF** \$ _____
price in writing

3. **R&S ex. Benches, complete. – Per Lump Sum**

_____ **SF** \$ _____
price in writing

4. **R&S ex. Pavers, complete. – Per Square Foot**

_____ **SF** \$ _____
price in writing

5. **R&D Turf and Topsoil to 12" depth, complete. – Per Cubic Yard**

_____ **CY** \$ _____
price in writing

6. **R&D Concrete Pad, complete. – Lump Sum**

_____ **LS** \$ _____
price in writing

7. **F&I 4" Concrete Pad, complete. – Per Square Foot**

_____ **SF** \$ _____
price in writing

Please note that the list above is not intended to include all items required to complete the base bid scope of work but can and shall be used to adjust the contract prior to or after award – in the best interest of the City of Providence.

BIDDER: _____



**PROVIDENCE
PARKS DEPARTMENT**
DALRYMPLE BOATHOUSE
ROGER WILLIAMS PARK
PROVIDENCE, RI 02905



**Providence
Parks**

COPYRIGHT (C) CITY OF
PROVIDENCE PARKS
DEPARTMENT, ALL RIGHTS
RESERVED 2026.

NO PART OF THIS DOCUMENT MAY BE
REPRODUCED, STORED IN A RETRIEVAL
SYSTEM OR TRANSMITTED IN ANY FORM OR
BY ANY MEANS, ELECTRONIC,
MECHANICAL, PHOTOCOPYING,
RECORDING OR OTHERWISE WITHOUT THE
PRIOR WRITTEN PERMISSION OF THE CITY OF
PROVIDENCE PARKS DEPARTMENT. ANY
MODIFICATIONS TO THIS DOCUMENT
WITHOUT THE WRITTEN PERMISSION OF
THE CITY OF PROVIDENCE PARKS
DEPARTMENT SHALL RENDER IT INVALID
AND UNUSABLE.

STAMP

PROJECT:


**Site Improvements at
Hopkins Sq. Park**

**465 Branch Ave
Providence, RI**

REVISIONS:

#	Date	Issued For:
- 2 -	08.12.26 -	ADDENDUM2
-	-	-
-	-	-

NORTH ARROW

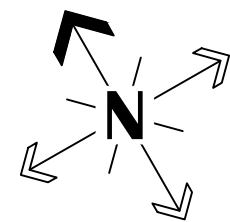

SCALE

0 10' 20' 40'



SCALE: 1"=20'

DRAWING INFO

DATE ISSUED: 07/27/2026
PROJECT NO: HOPK.25.01
DRAWN BY: II
CHECKED BY: MG


SHEET TITLE

**Ex Conditions
/ Demo Plan**


L-2

2 OF 6

FILE: HOPK.25.01-PLANS.dwg

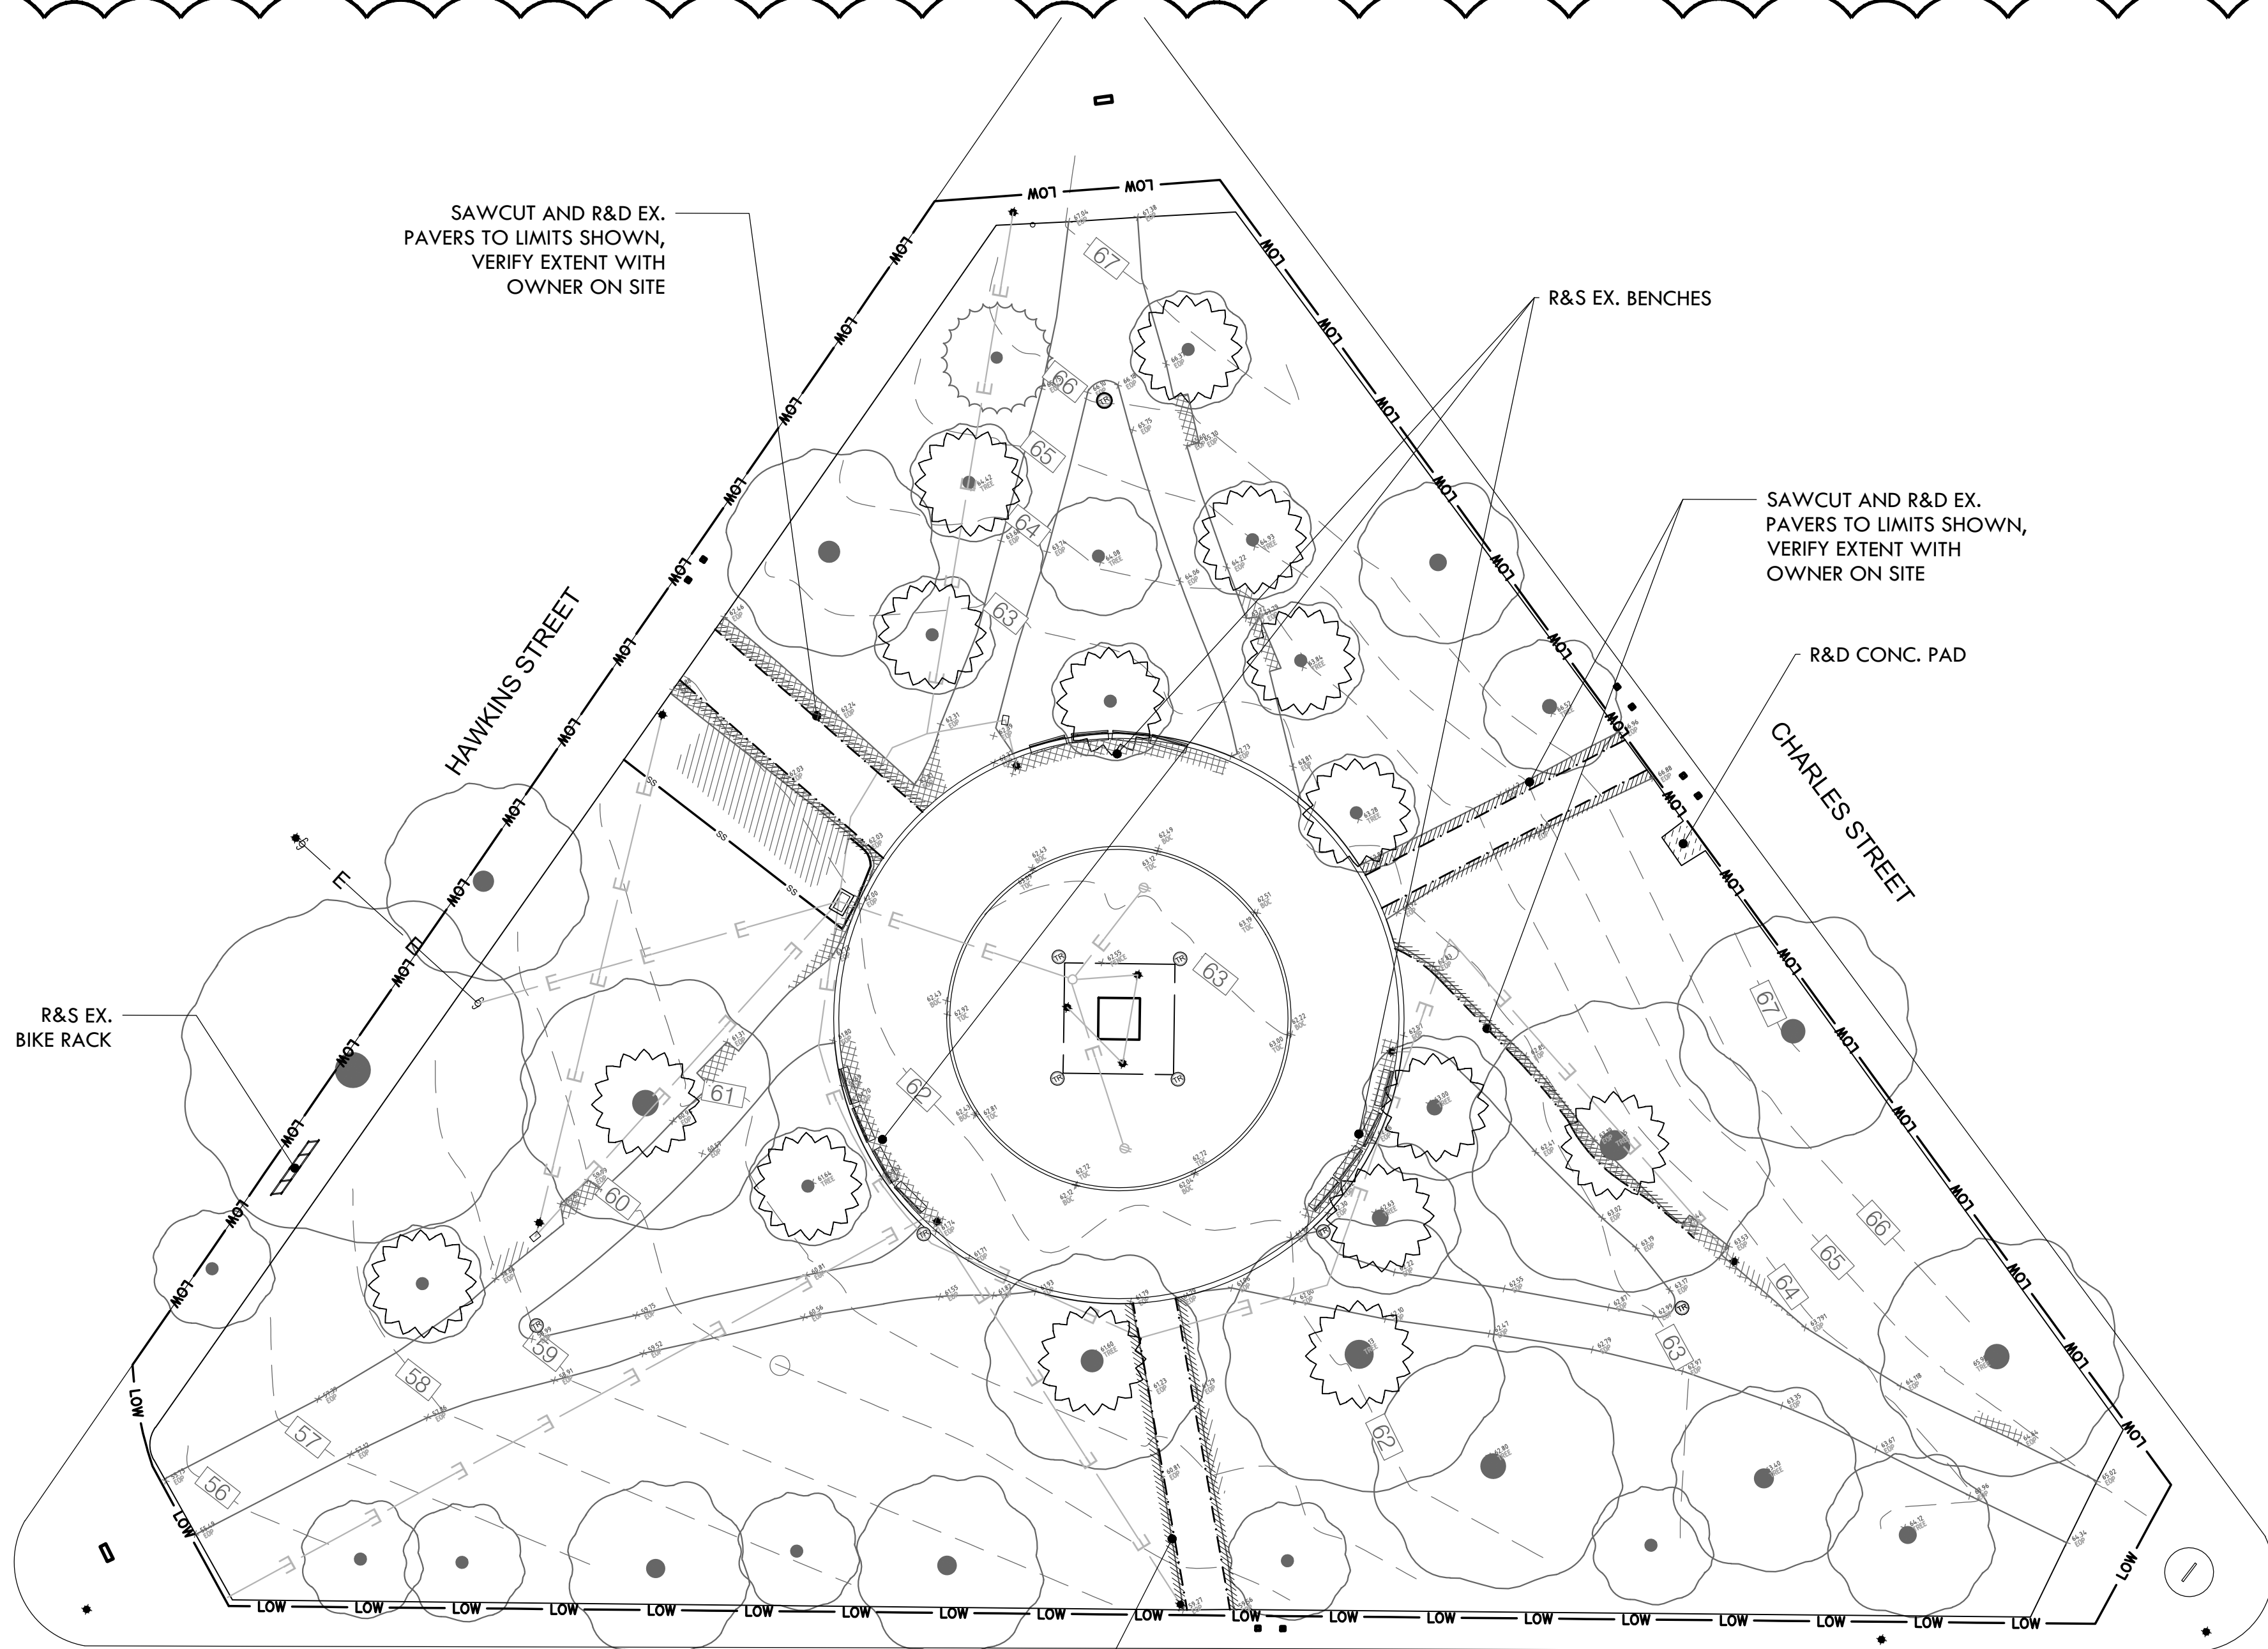


A BASE BID ITEMS
SCALE 1"=20'

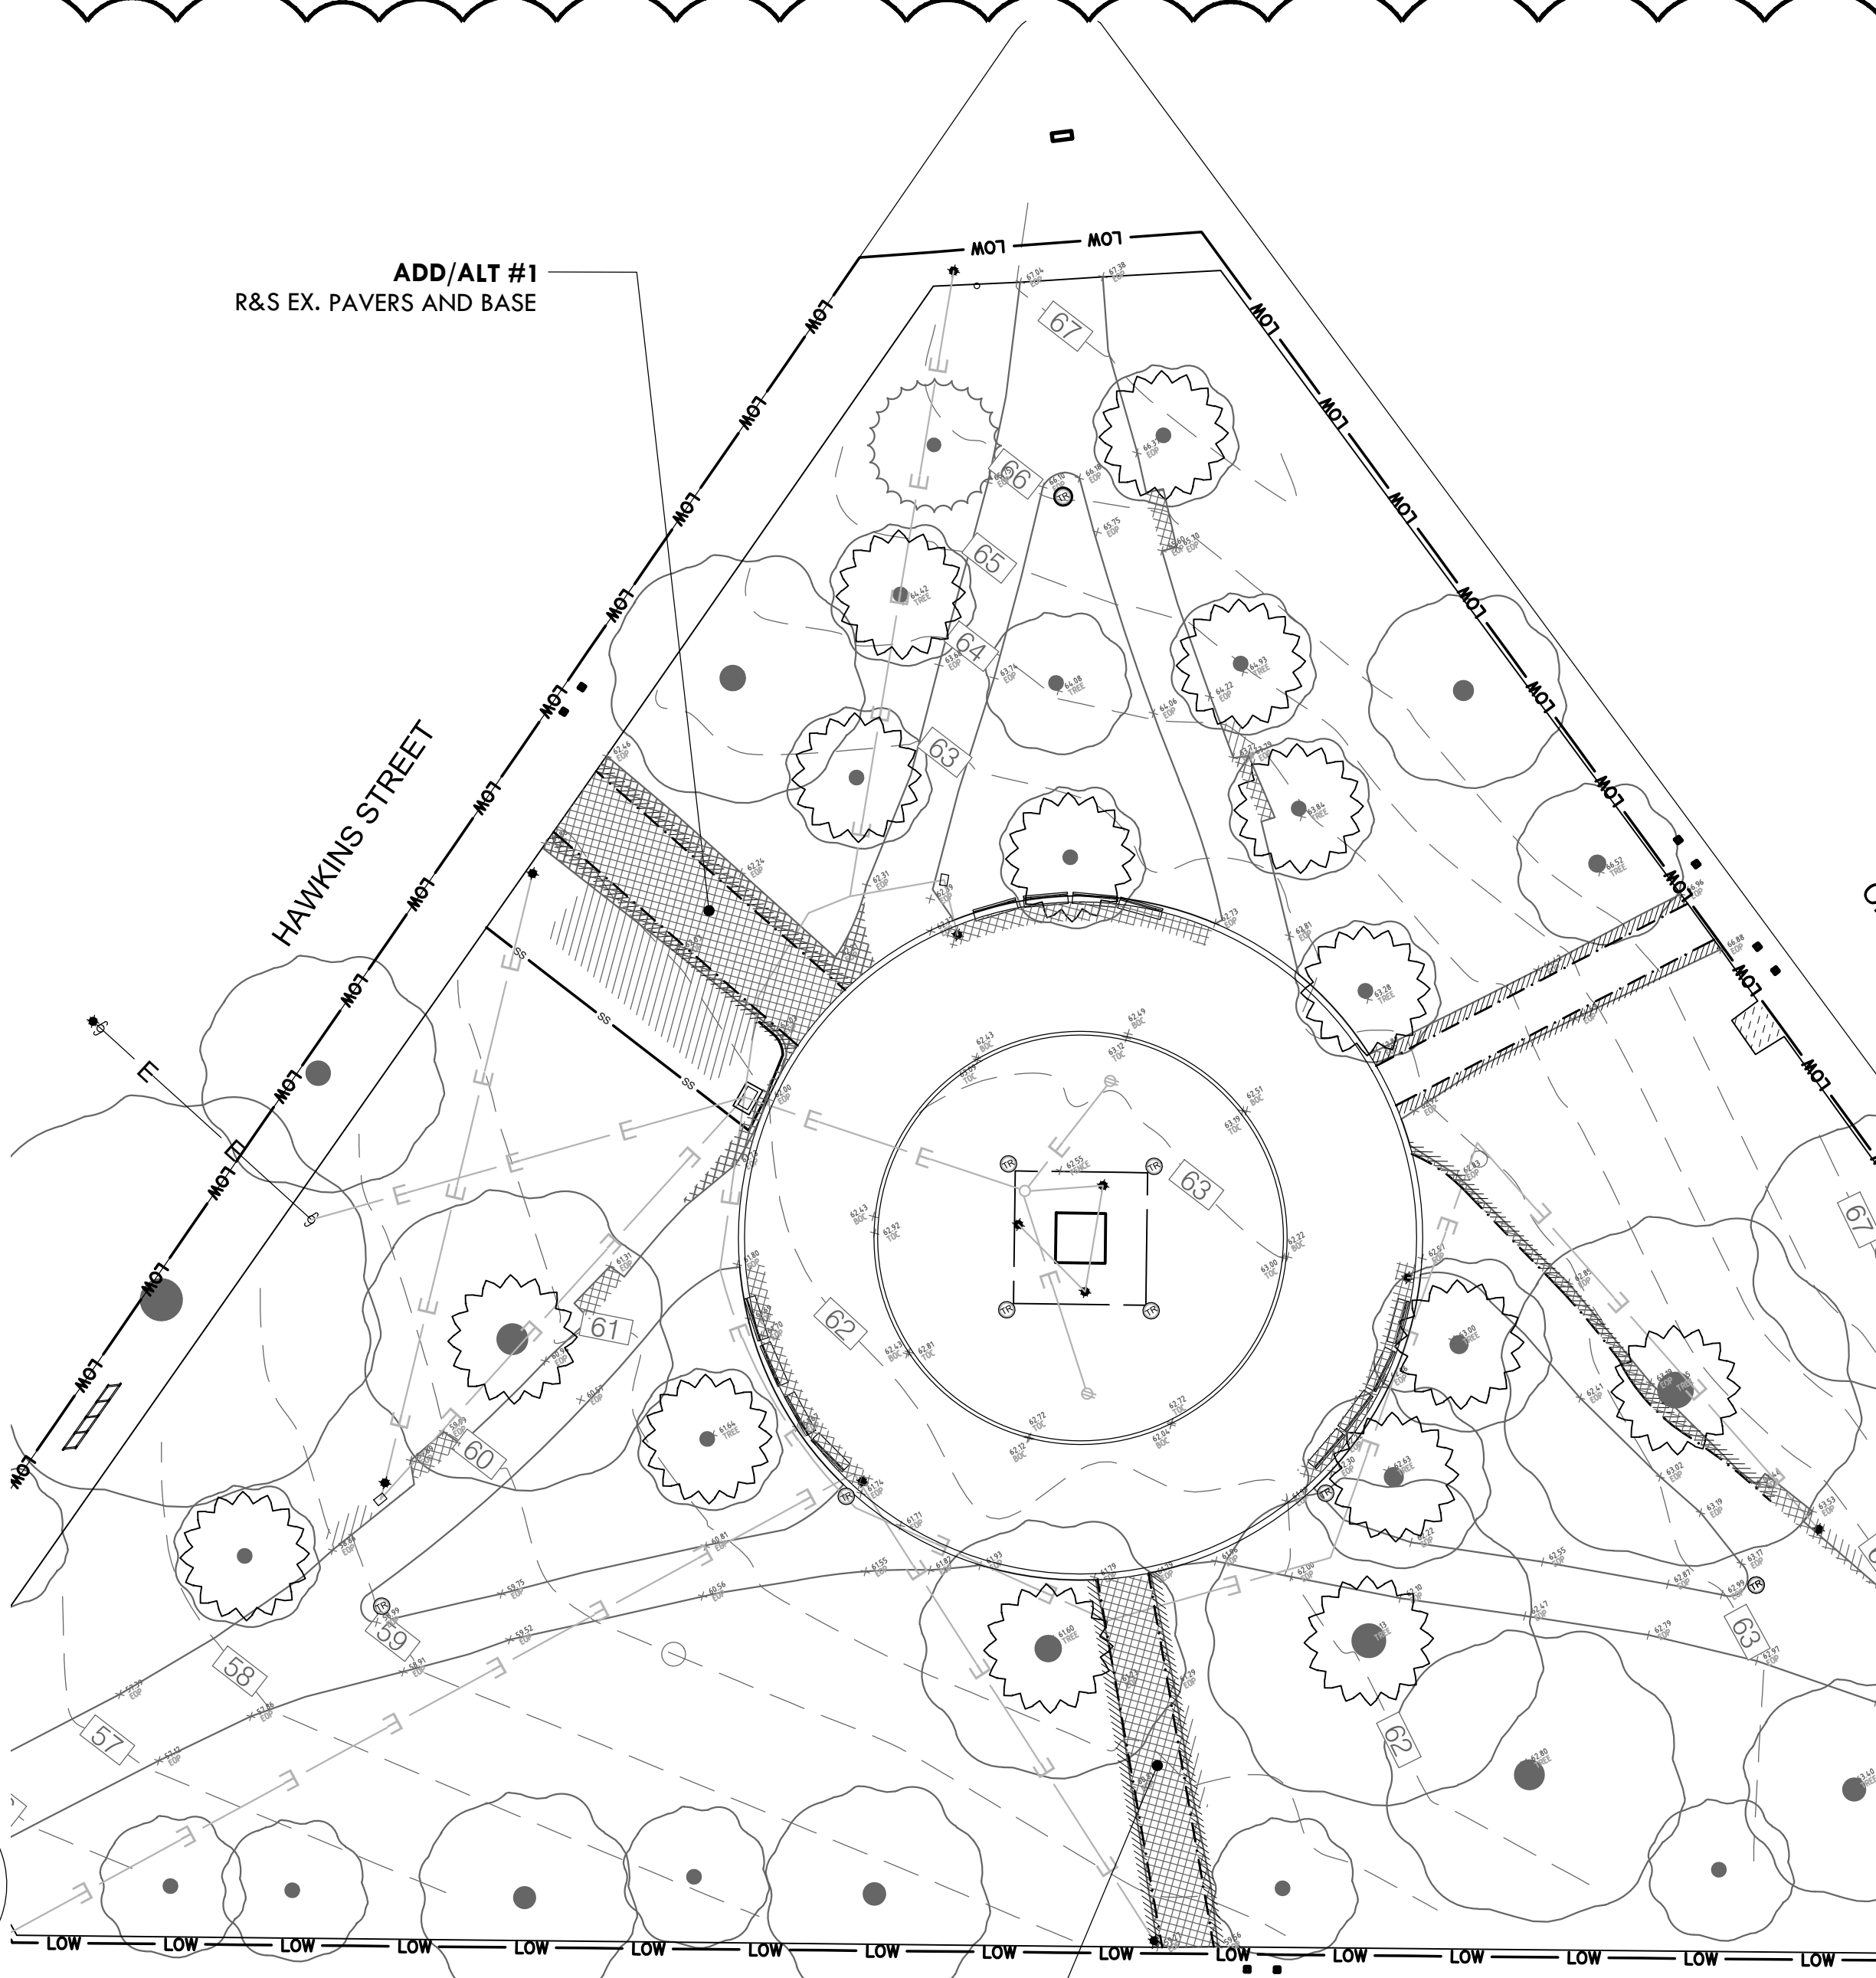

B ADD ALT ITEMS
SCALE 1"=20'

DEMOLITION PLAN LEGEND

— LOW — LOW —	LIMIT OF WORK		R&S EX. PAVERS
— SS —	SILT SOCK (1 L-3)		STRIP TURF & TOPSOIL TO 12" DEPTH
~~~~~	TREE PROTECTION FENCE (2 L-3)		R&D CONC. PAD
— E — E —	ELECTRIC LINE		LIGHTS / LIGHT POLES
	SAWCUT		

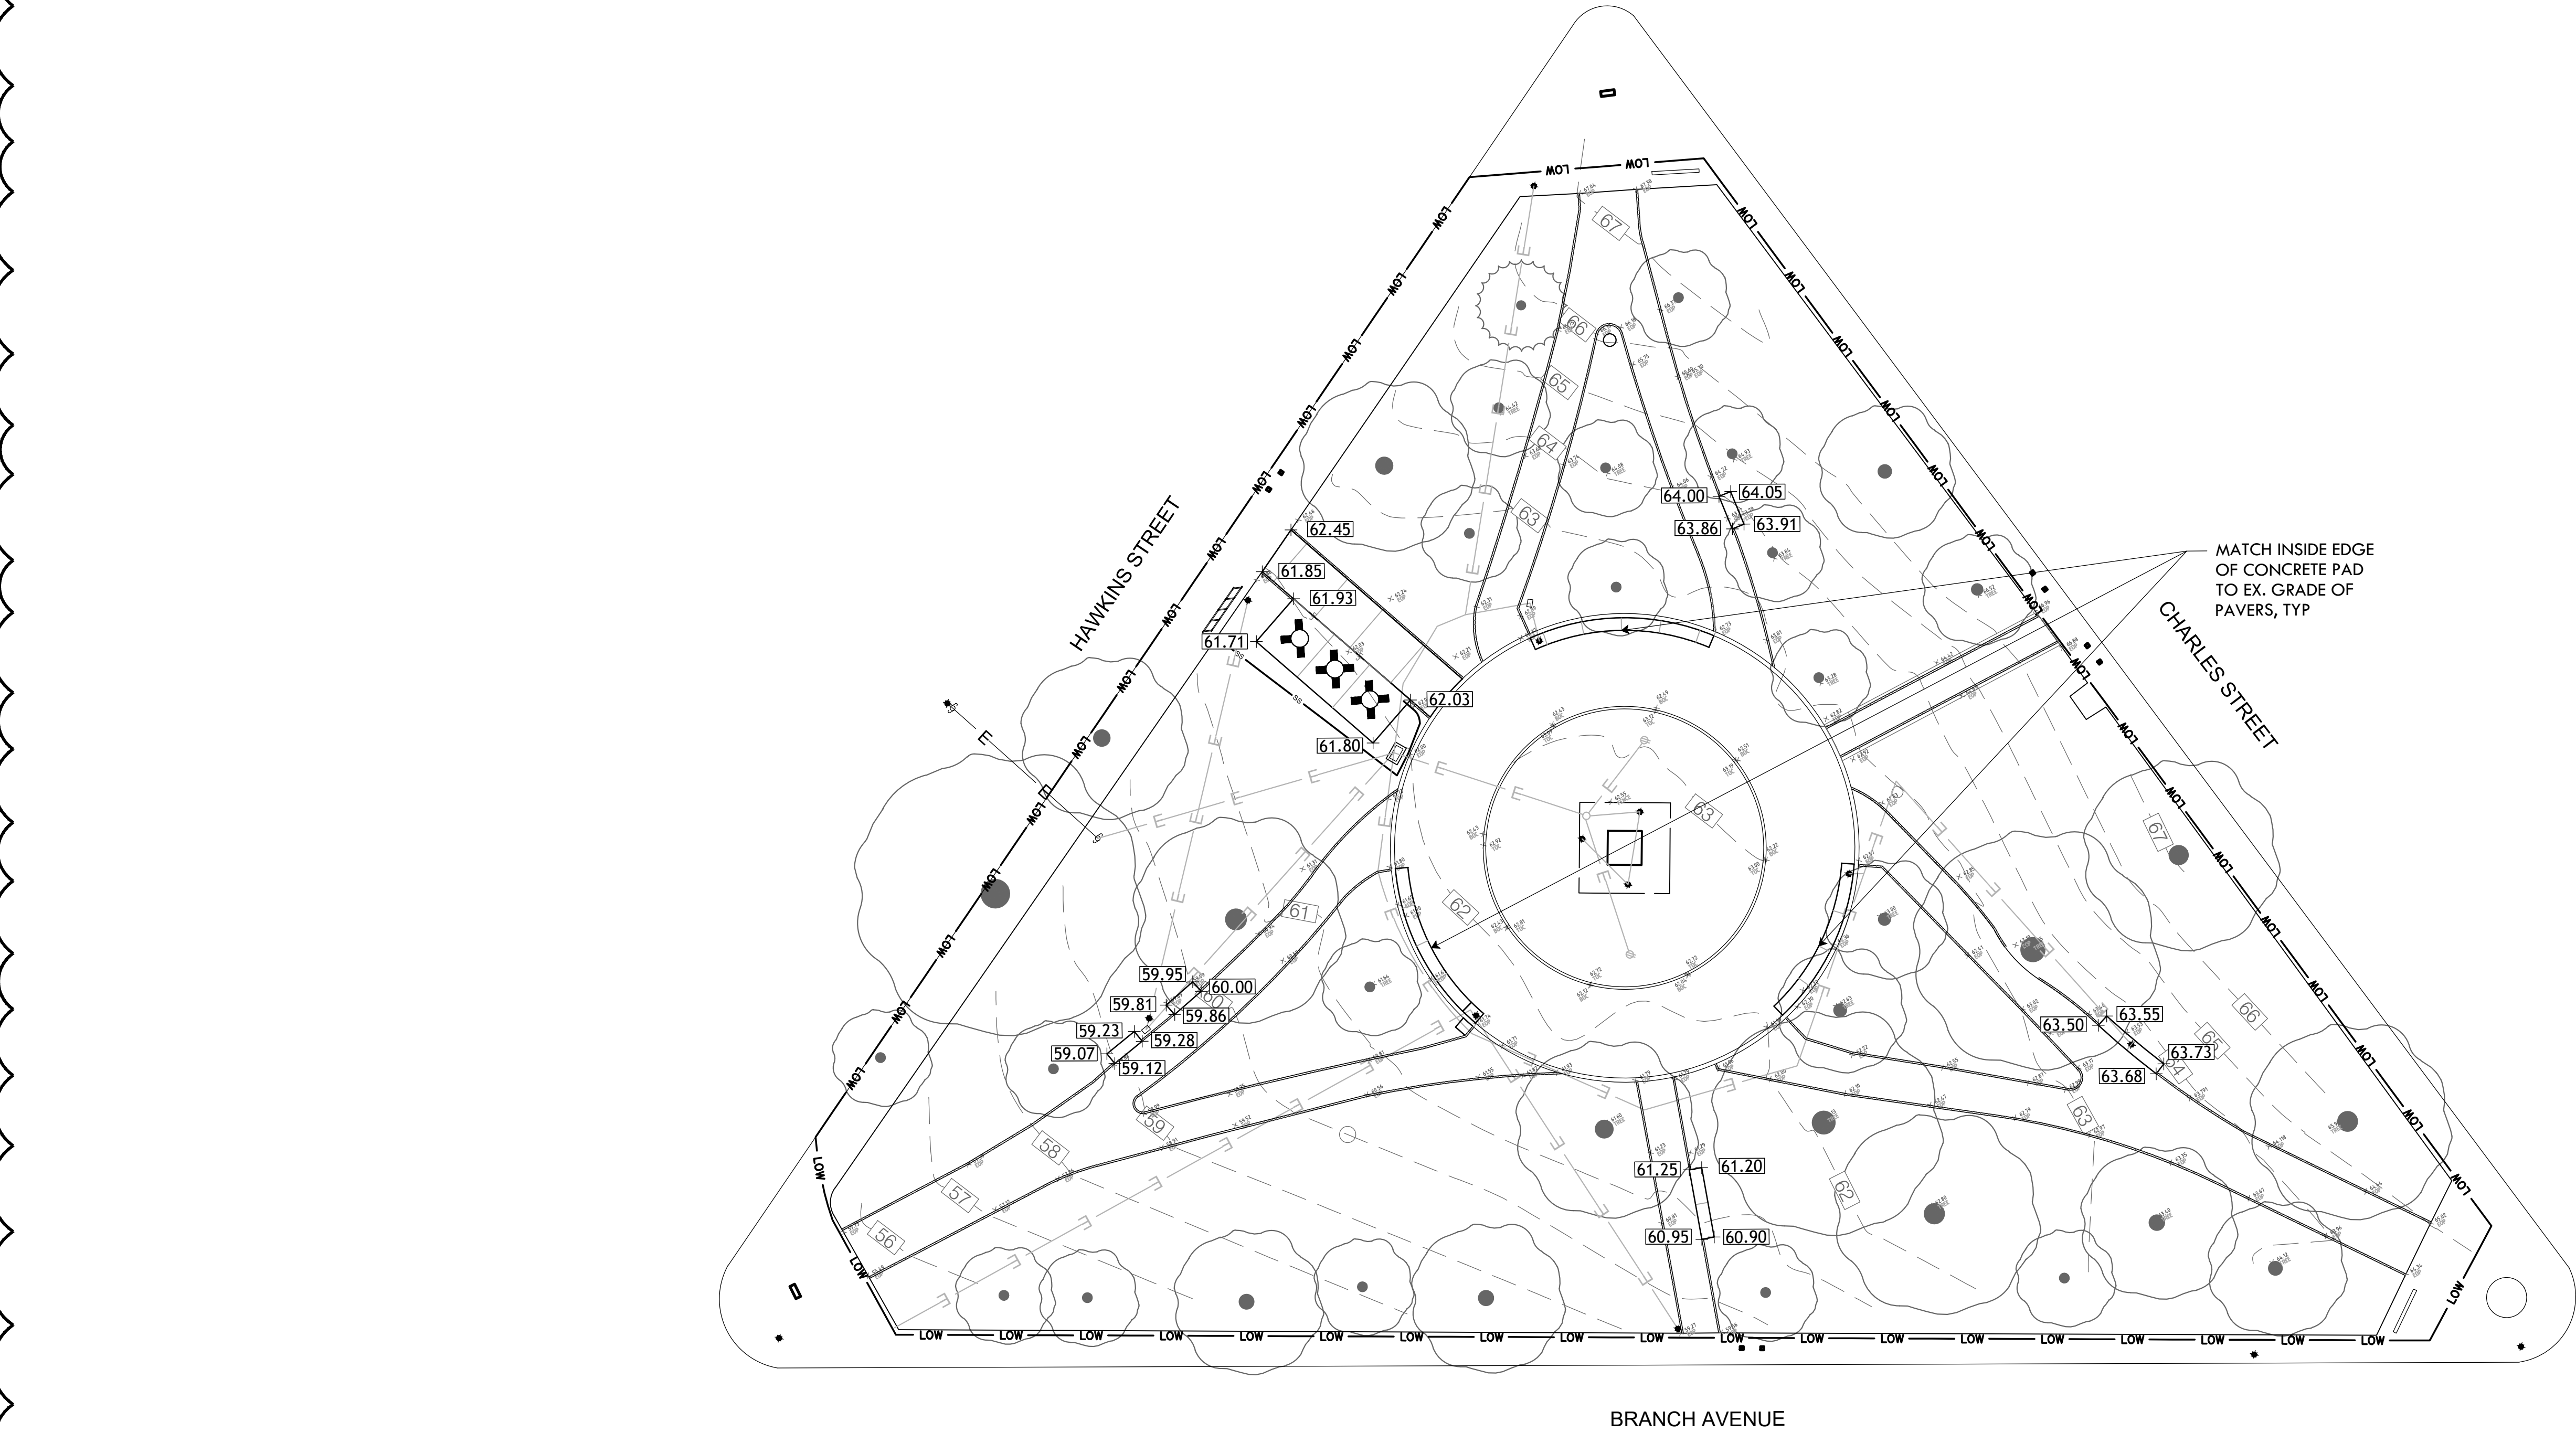

## GRADING LEGEND

- 97.96 EXISTING GRADE
- - -98- - - EXISTING CONTOUR
- + [97.83] PROPOSED GRADE



**PROVIDENCE  
PARKS DEPARTMENT**  
DALRYMPLE BOATHOUSE  
ROGER WILLIAMS PARK  
PROVIDENCE, RI 02905



**Providence  
Parks**

COPYRIGHT (C) CITY OF  
PROVIDENCE PARKS  
DEPARTMENT, ALL RIGHTS  
RESERVED 2026.

NO PART OF THIS DOCUMENT MAY BE  
REPRODUCED, STORED IN A RETRIEVAL  
SYSTEM OR TRANSMITTED IN ANY FORM OR  
BY ANY MEANS, ELECTRONIC,  
MECHANICAL, PHOTOCOPYING,  
RECORDING OR OTHERWISE WITHOUT THE  
PRIOR WRITTEN PERMISSION OF THE CITY  
OF PROVIDENCE PARKS DEPARTMENT. ANY  
MODIFICATIONS TO THIS DOCUMENT  
WITHOUT THE WRITTEN PERMISSION OF  
THE CITY OF PROVIDENCE PARKS  
DEPARTMENT SHALL RENDER IT INVALID  
AND UNUSABLE.

STAMP

PROJECT:


**Site Improvements at  
Hopkins Sq. Park**

**465 Branch Ave  
Providence, RI**

REVISIONS:

#	Date	Issued For:
- 2 -	08.12.26 -	ADDENDUM2
-	-	-
-	-	-

NORTH ARROW

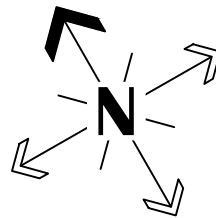

SCALE

0 10' 20' 40'

SCALE: 1"=20'

DRAWING INFO

DATE ISSUED: 07/27/2026  
PROJECT NO: HOPK.25.01  
DRAWN BY: II  
CHECKED BY: MG

SHEET TITLE

**Grading Plan**

**L-3**

3 OF 6

FILE: HOPK.25.01-PLANS.dwg



**PROVIDENCE  
PARKS DEPARTMENT**  
DALRYMPLE BOATHOUSE  
ROGER WILLIAMS PARK  
PROVIDENCE, RI 02905



**Providence  
Parks**

COPYRIGHT (C) CITY OF  
PROVIDENCE PARKS  
DEPARTMENT, ALL RIGHTS  
RESERVED 2026.

NO PART OF THIS DOCUMENT MAY BE  
REPRODUCED, STORED IN A RETRIEVAL  
SYSTEM OR TRANSMITTED IN ANY FORM OR  
BY ANY MEANS, ELECTRONIC,  
MECHANICAL, PHOTOCOPYING,  
RECORDING OR OTHERWISE WITHOUT THE  
PRIOR WRITTEN PERMISSION OF THE CITY OF  
PROVIDENCE PARKS DEPARTMENT. ANY  
MODIFICATIONS TO THIS DOCUMENT  
WITHOUT THE WRITTEN PERMISSION OF  
THE CITY OF PROVIDENCE PARKS  
DEPARTMENT SHALL RENDER IT INVALID  
AND UNUSABLE.

STAMP

PROJECT:


**Site Improvements at  
Hopkins Sq. Park**

**465 Branch Ave  
Providence, RI**

REVISIONS:

#	Date	Issued For:
- 2 -	08.12.26 -	ADDENDUM2
-	-	-
-	-	-

NORTH ARROW

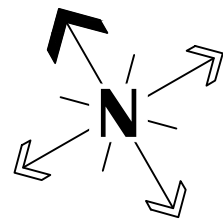

SCALE

0 10' 20' 40'

SCALE: 1"=20'

DRAWING INFO


DATE ISSUED: 07/27/2026  
PROJECT NO: HOPK.25.01  
DRAWN BY: II  
CHECKED BY: MG

SHEET TITLE

**Materials Plan**

**L-4**


4 OF 6

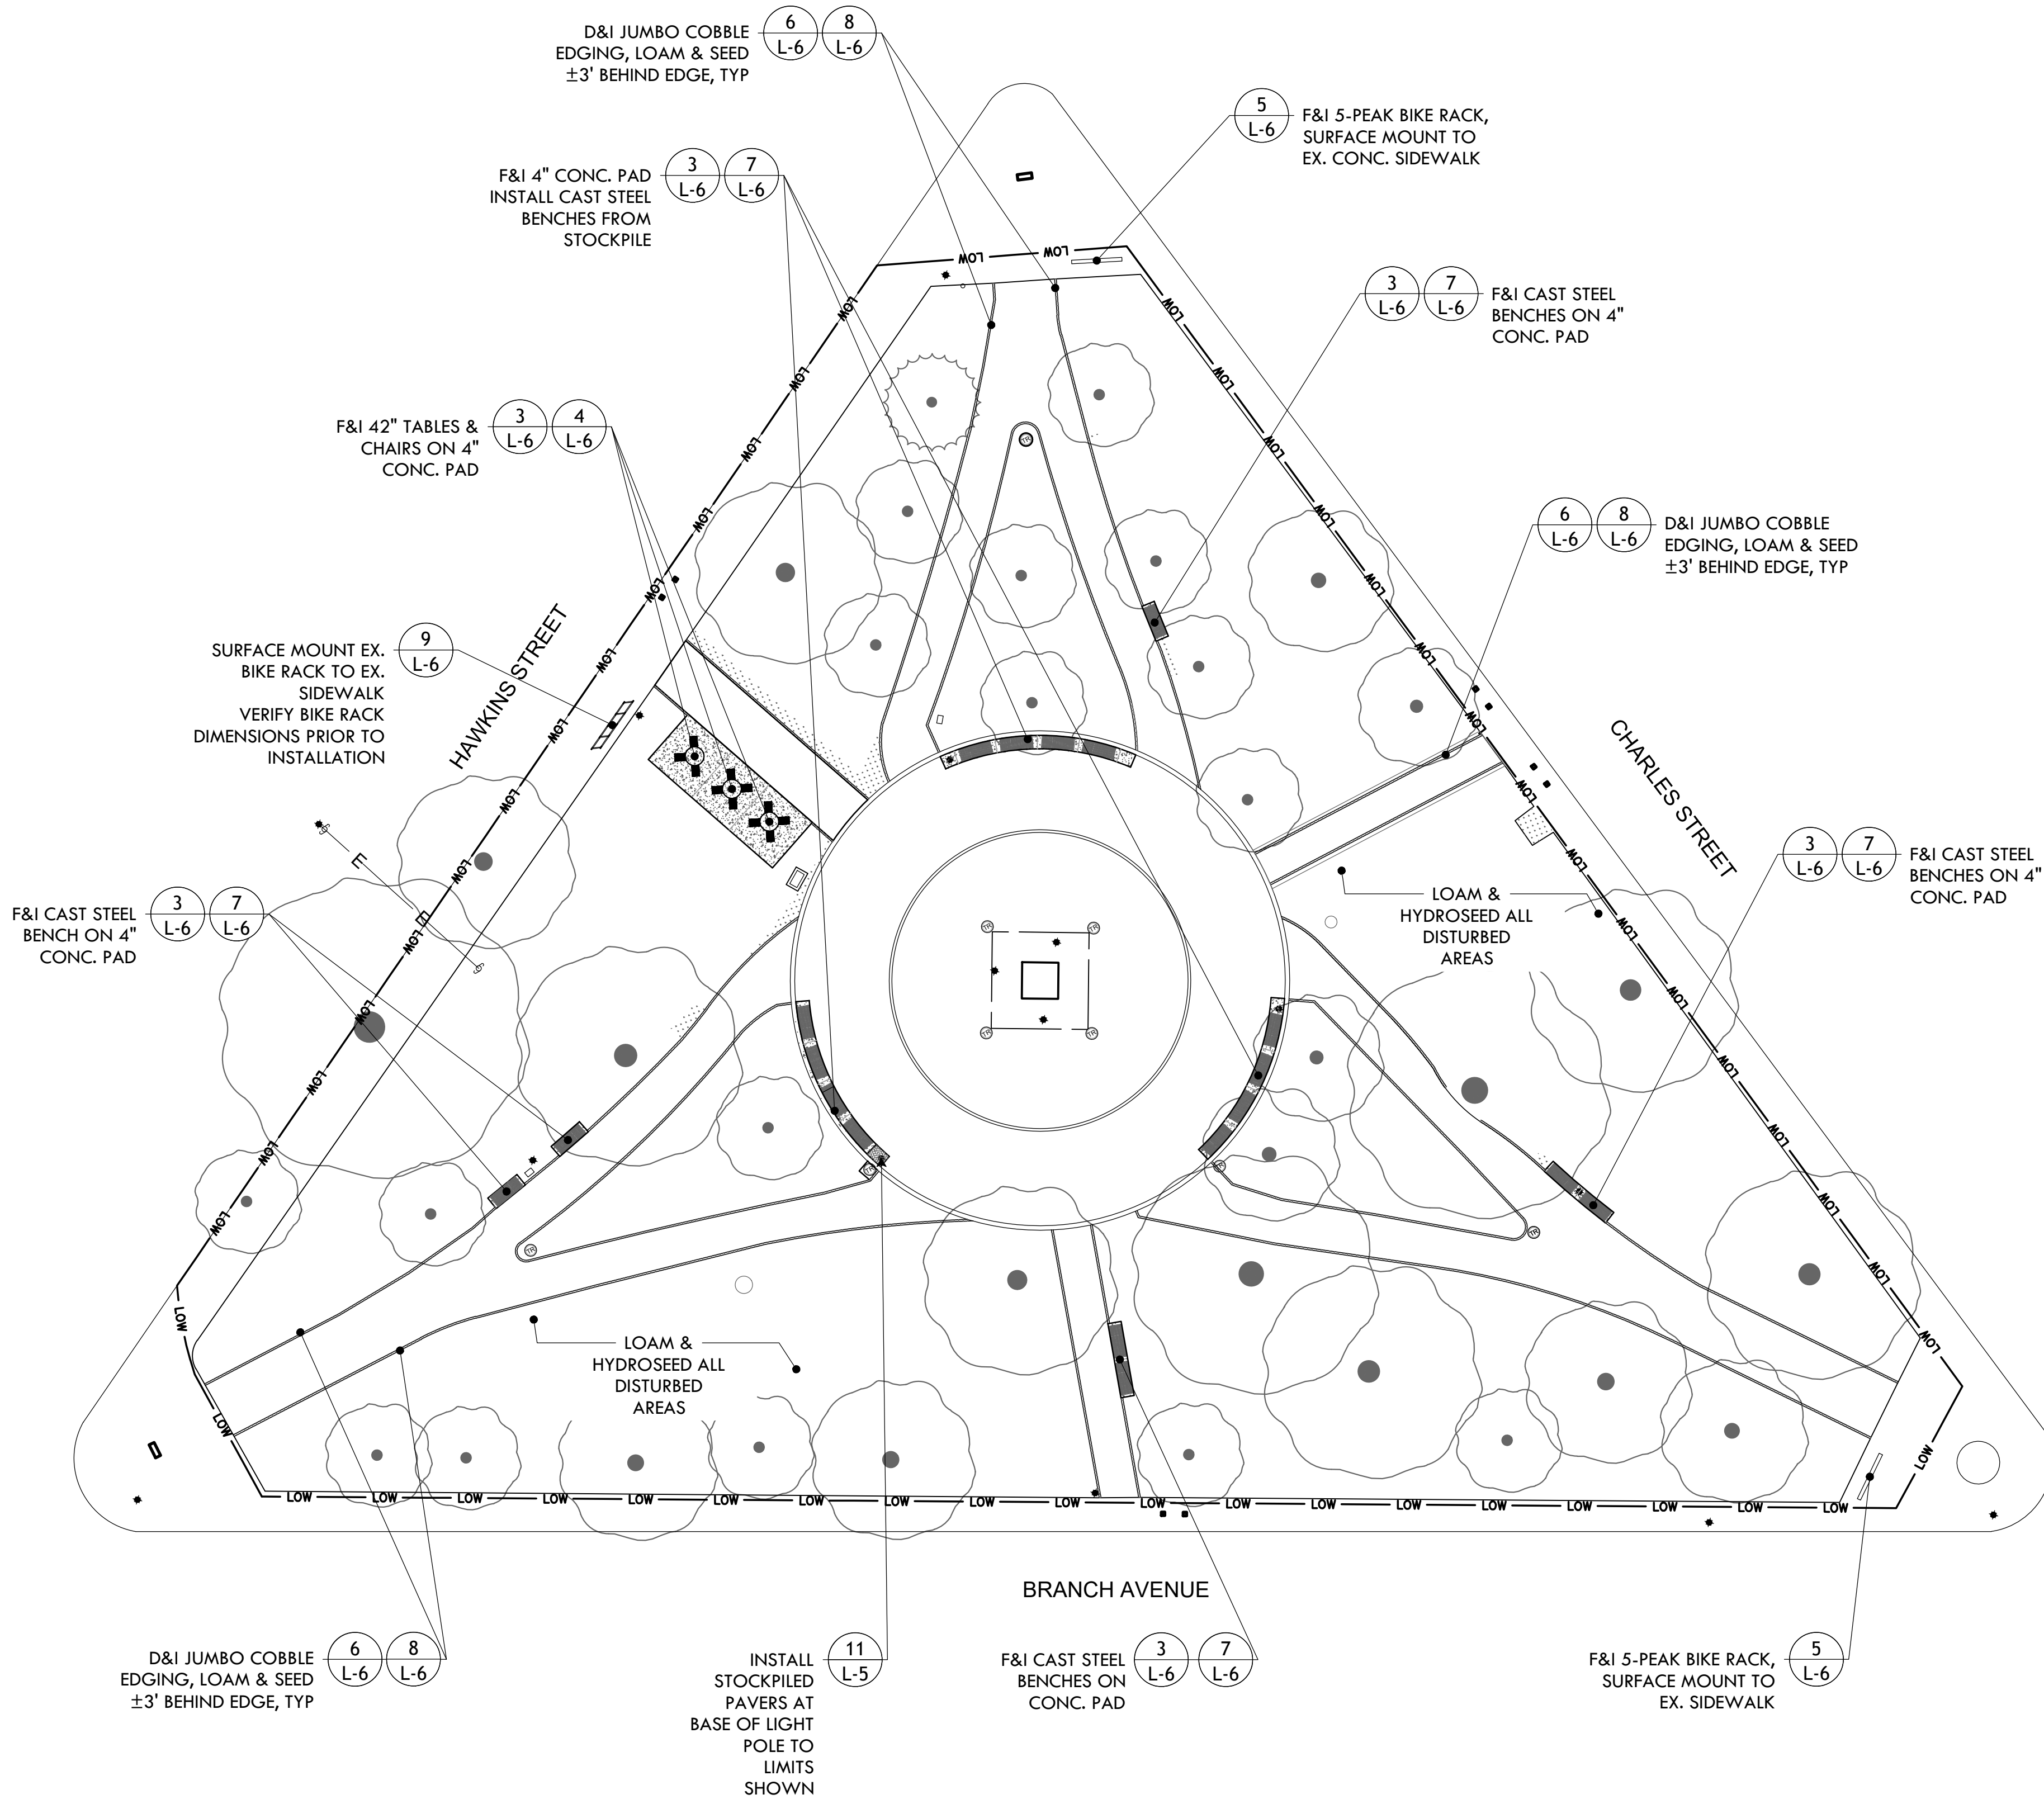

**A** BASE BID ITEMS  
SCALE 1"=20'

**MATERIALS PLAN LEGEND**

	JUMBO COBBLE EDGING		4" AND 6" POURED CONCRETE PAVING
	CAST STEEL BENCH		LOAM & HYDROSEED FORMERLY PAVED AREAS
	OVERHEAD ELECTRIC LINE		

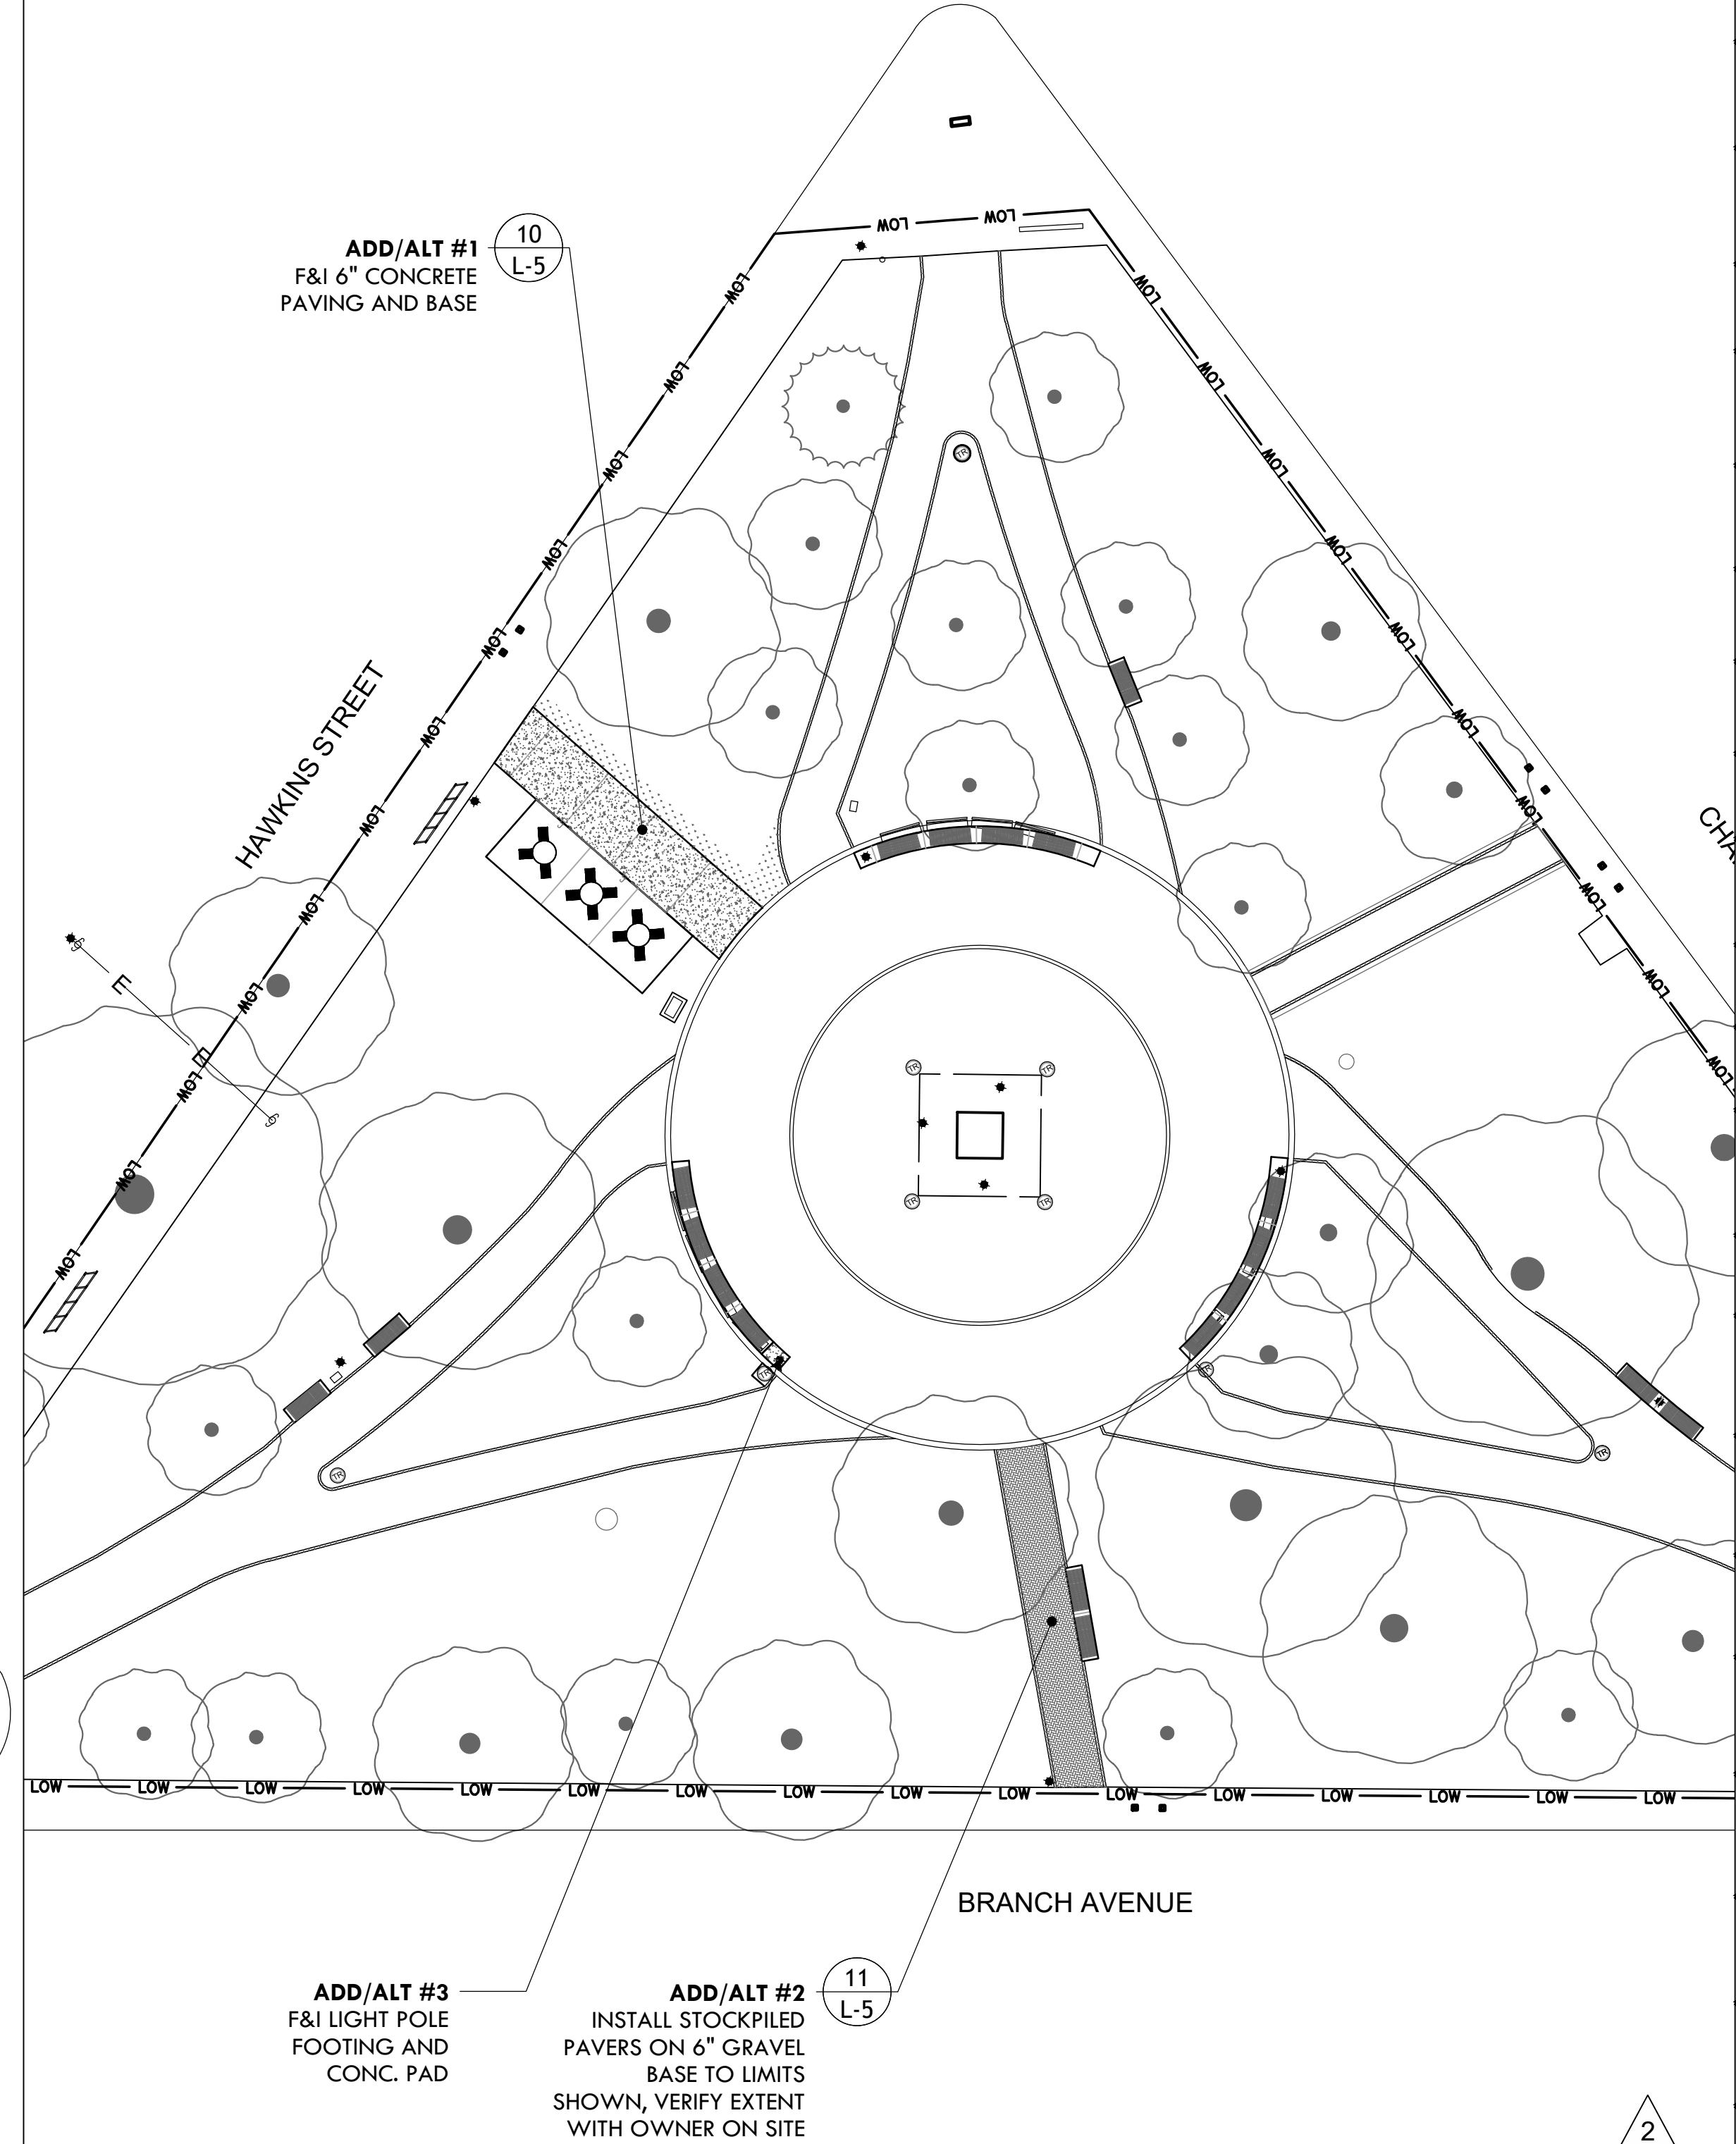

**B** ADD ALT ITEMS  
SCALE 1"=20'



**PROVIDENCE  
PARKS DEPARTMENT**  
DAIRYMPLE BOATHOUSE  
ROGER WILLIAMS PARK  
PROVIDENCE, RI 02905



**Providence  
Parks**

COPYRIGHT (C) CITY OF  
PROVIDENCE PARKS  
DEPARTMENT, ALL RIGHTS  
RESERVED 2026.

NO PART OF THIS DOCUMENT MAY BE  
REPRODUCED, STORED IN A RETRIEVAL  
SYSTEM OR TRANSMITTED IN ANY FORM OR  
BY ANY MEANS, ELECTRONIC,  
MECHANICAL, PHOTOCOPYING,  
RECORDING OR OTHERWISE WITHOUT THE  
PRIOR WRITTEN PERMISSION OF THE CITY OF  
PROVIDENCE PARKS DEPARTMENT. ANY  
MODIFICATIONS TO THIS DOCUMENT  
WITHOUT THE WRITTEN PERMISSION OF  
THE CITY OF PROVIDENCE PARKS  
DEPARTMENT SHALL RENDER IT INVALID  
AND UNUSABLE.

STAMP

PROJECT:


**Site Improvements at  
Hopkins Sq. Park**

**465 Branch Ave  
Providence, RI**


REVISIONS:

#	Date	Issued For:
- 2 -	08.12.26 -	ADDENDUM 2
-	-	-
-	-	-

NORTH ARROW

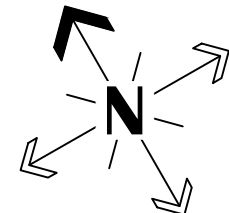

SCALE

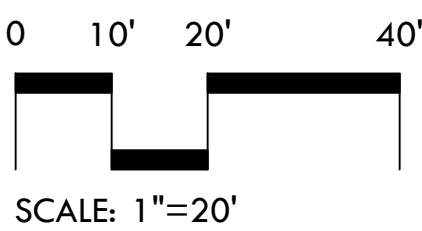

DRAWING INFO



DATE ISSUED: 07/27/2026  
PROJECT NO: HOPK.25.01  
DRAWN BY: II  
CHECKED BY: MG

SHEET TITLE


**Layout Plan**

**L-5**


5 OF 6

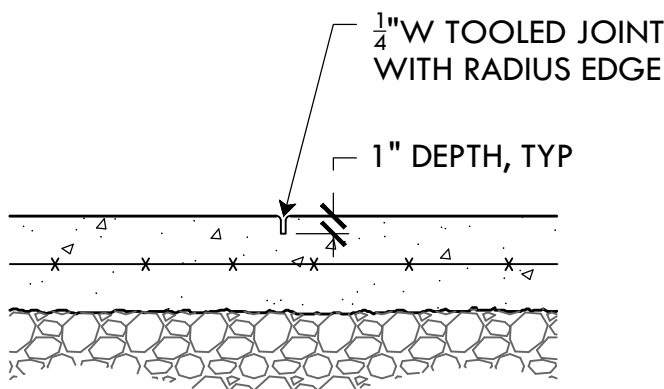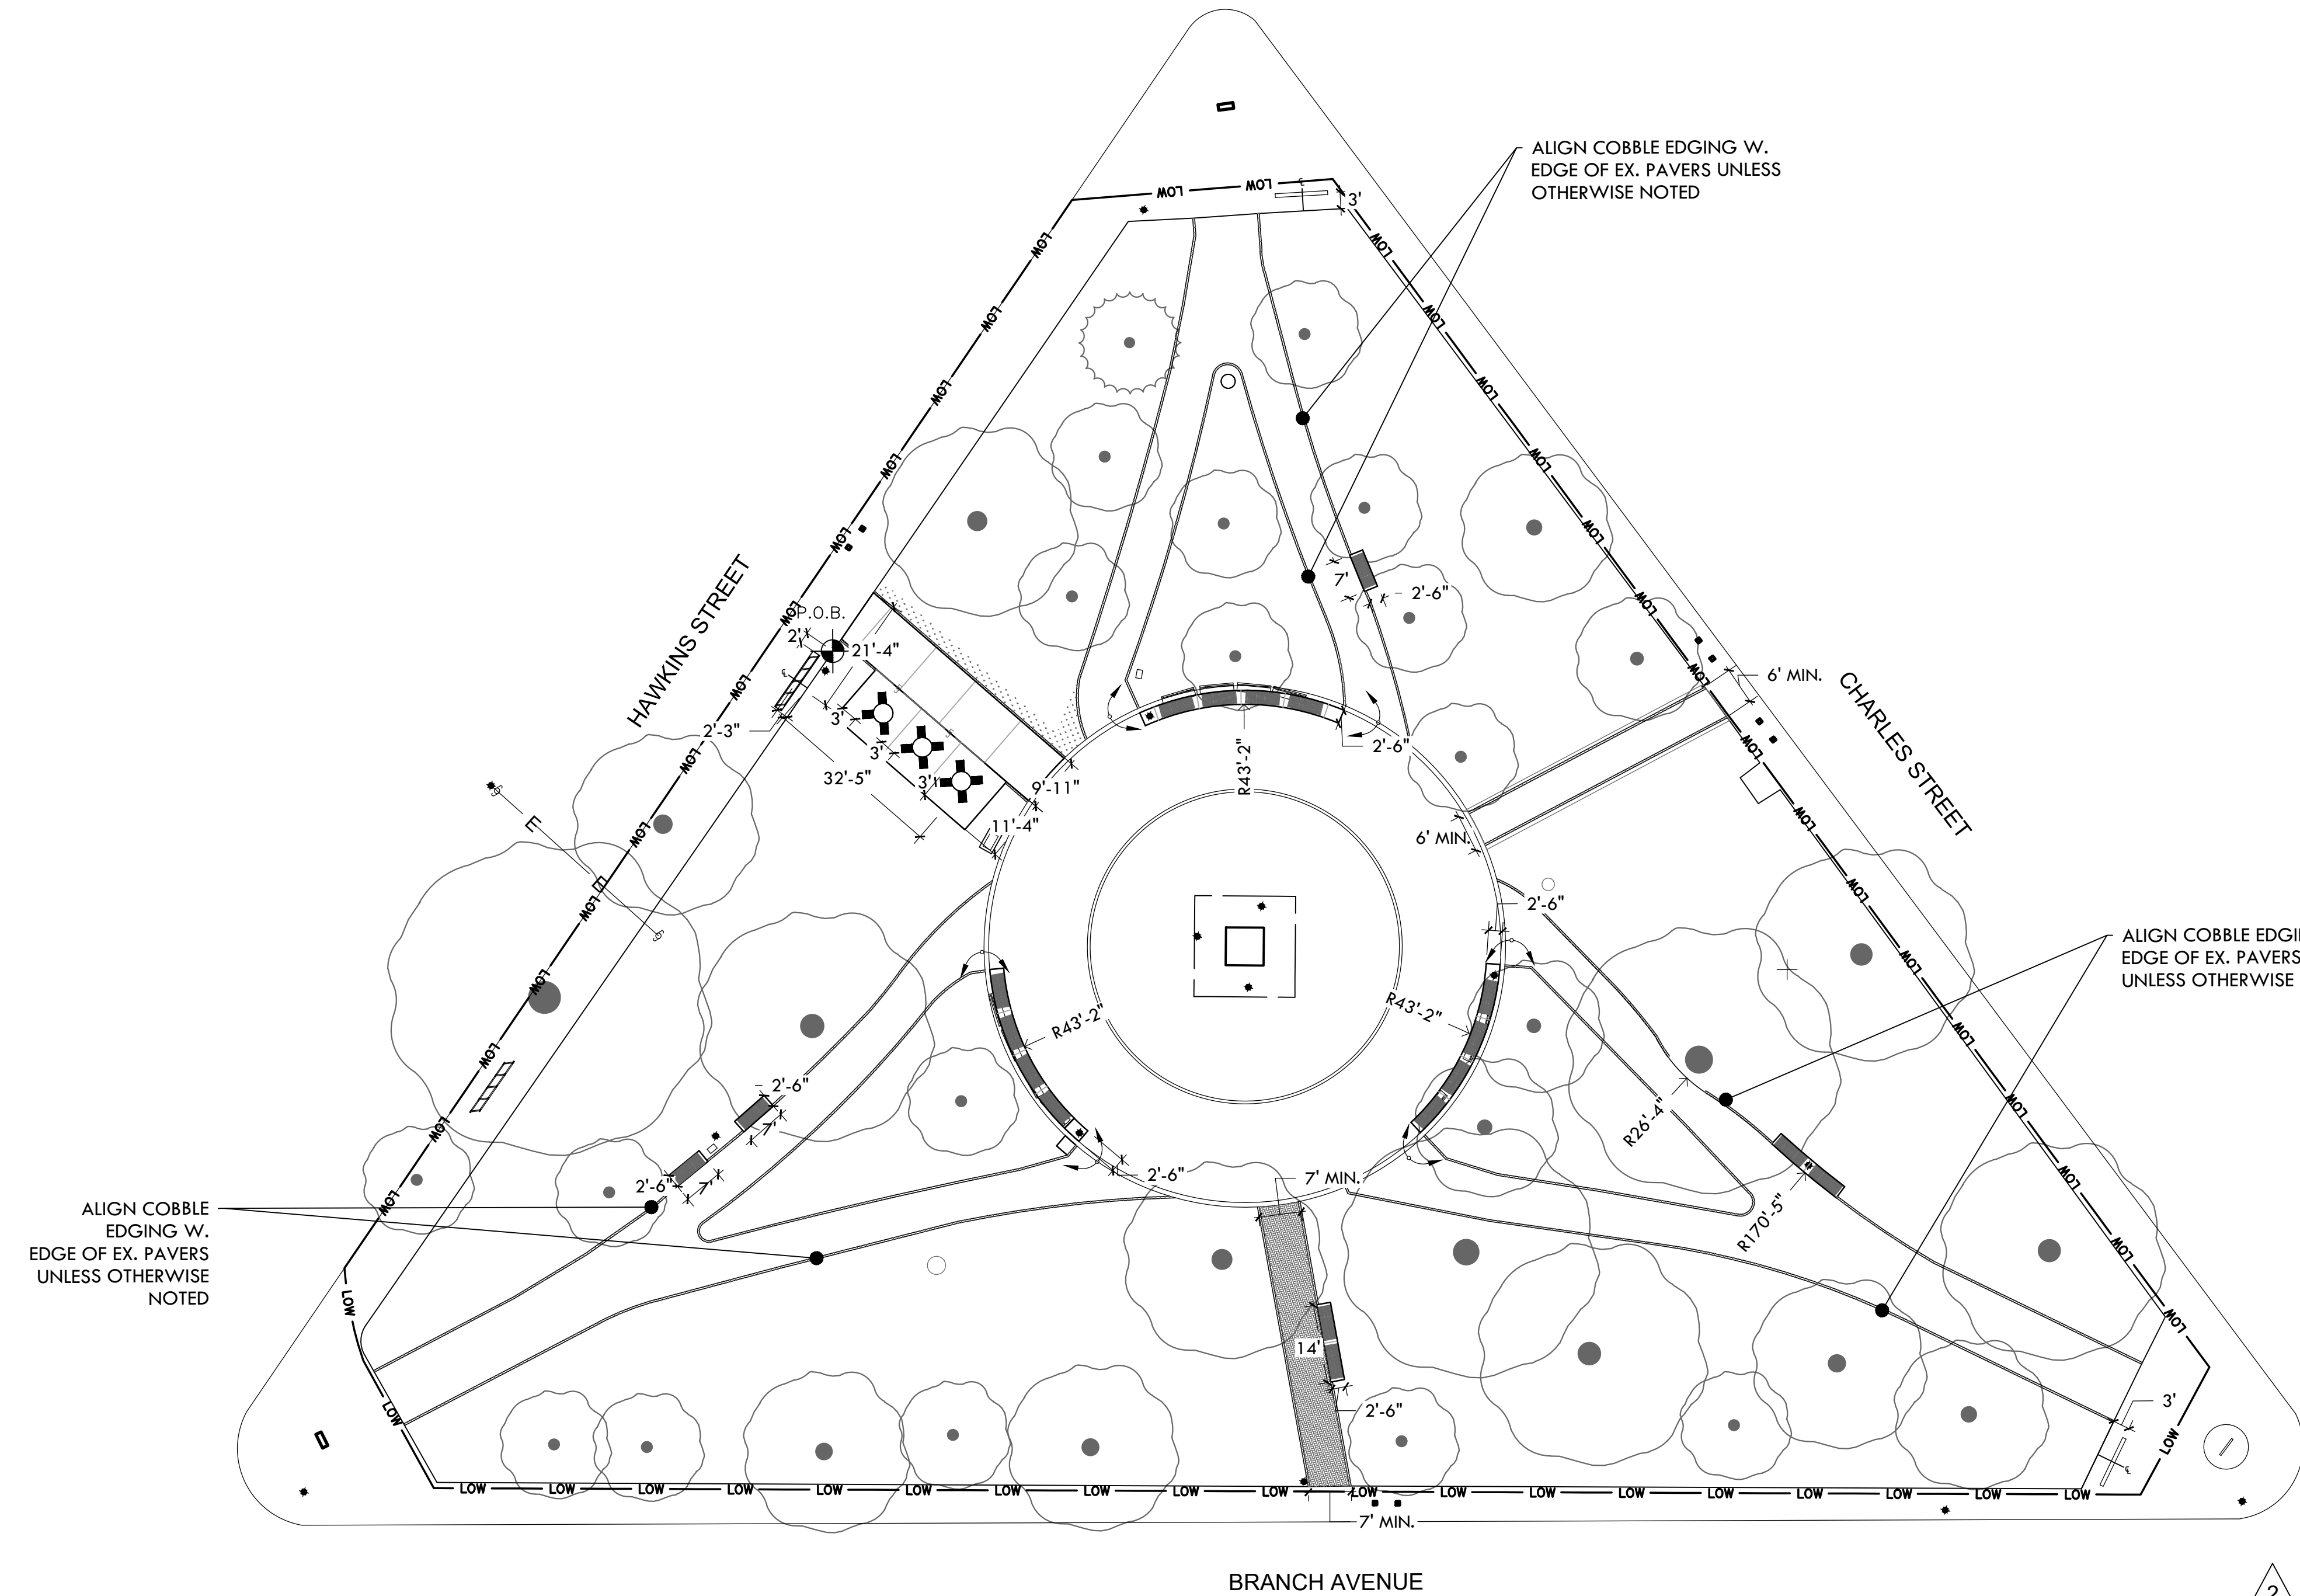

CONTROL JOINT

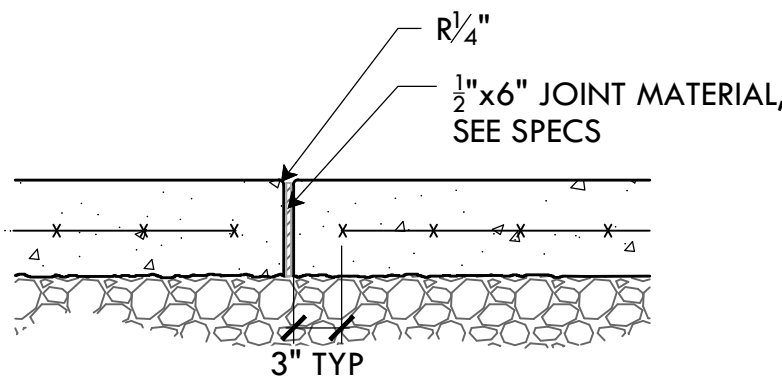


EXPANSION JOINT

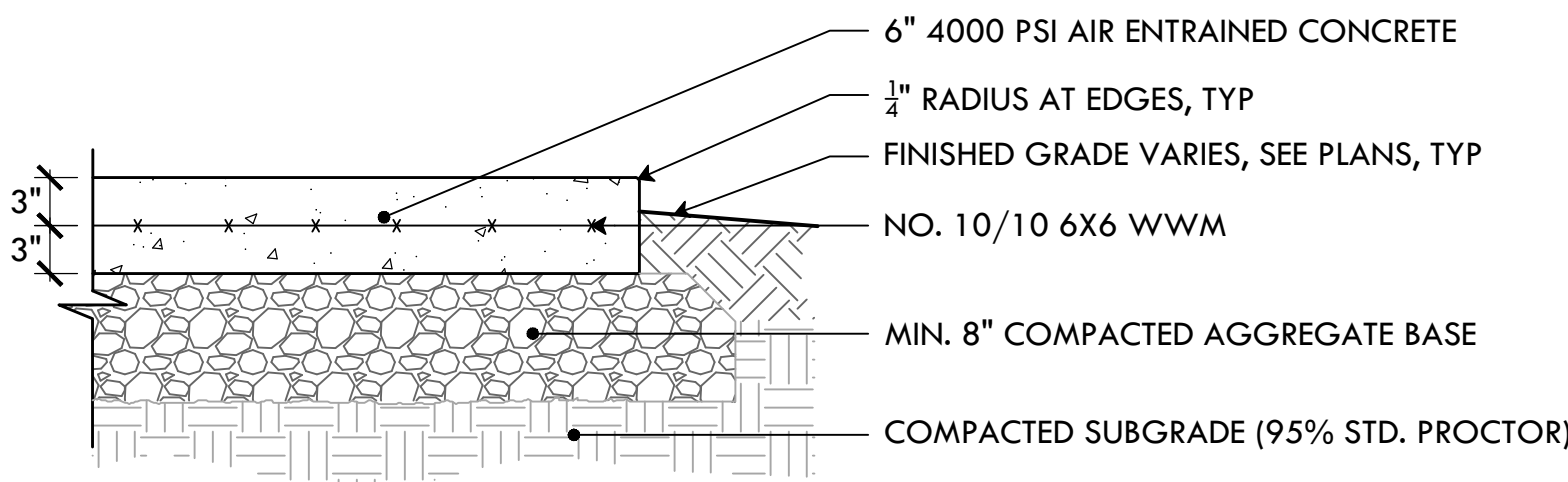

- NOTES:
1. CONCRETE TO BE MEDIUM BROOM FINISH UNLESS OTHERWISE NOTED
  2. SEE SPECS FOR CONCRETE MIX REQUIREMENTS


**10 6" CONCRETE PAVING**  
NTS

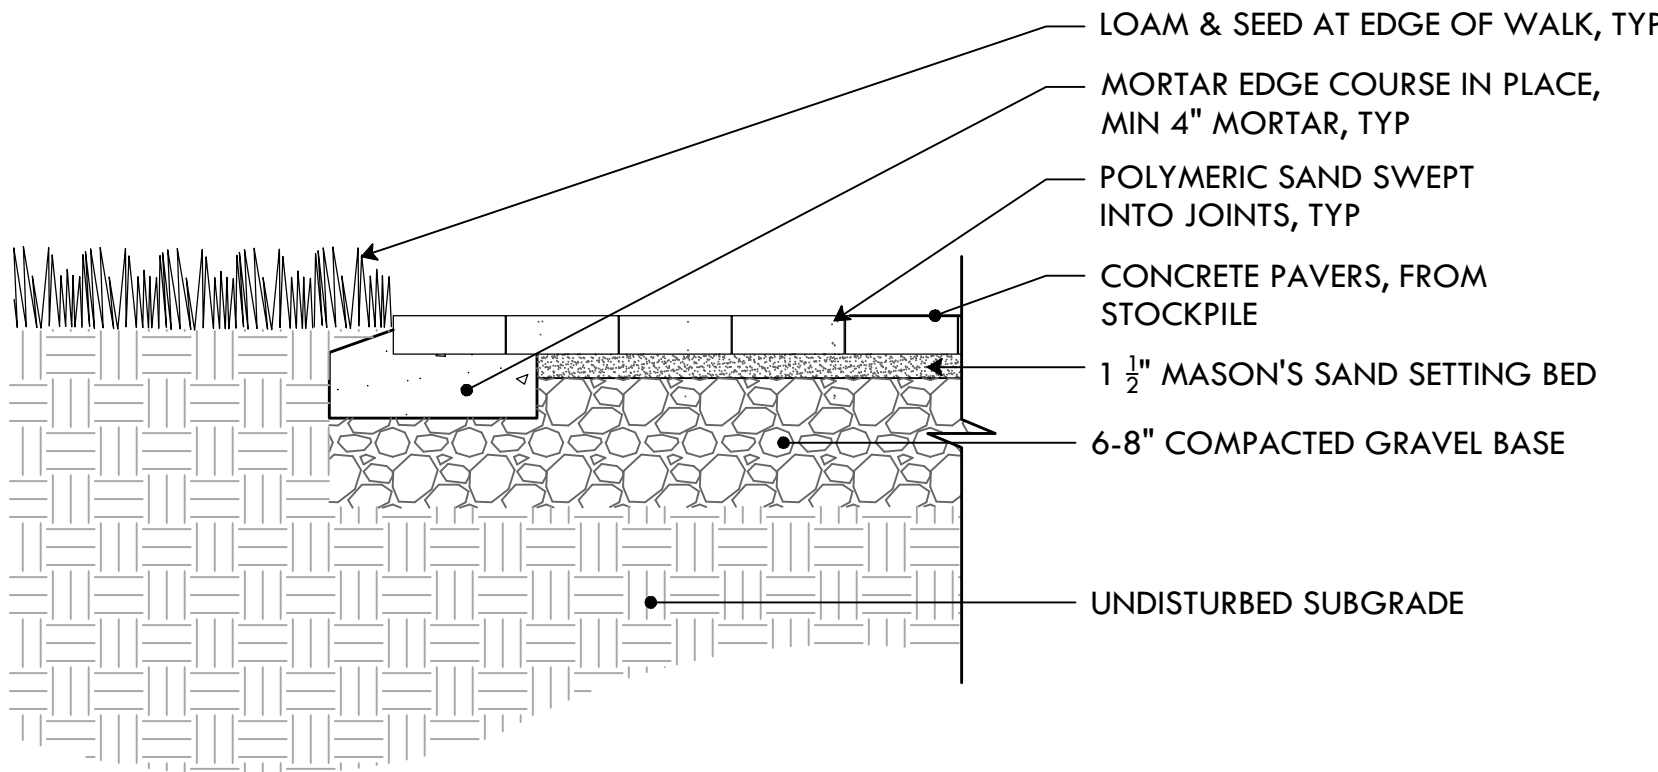

**11 CONCRETE PAVER SETTING**  
NTS

**LAYOUT LEGEND**


- P.O.B. POINT OF BEGINNING
- CENTERLINE
- DIMENSION
- ALIGN EDGES OR FACES
- OVERHEAD ELECTRIC LINE

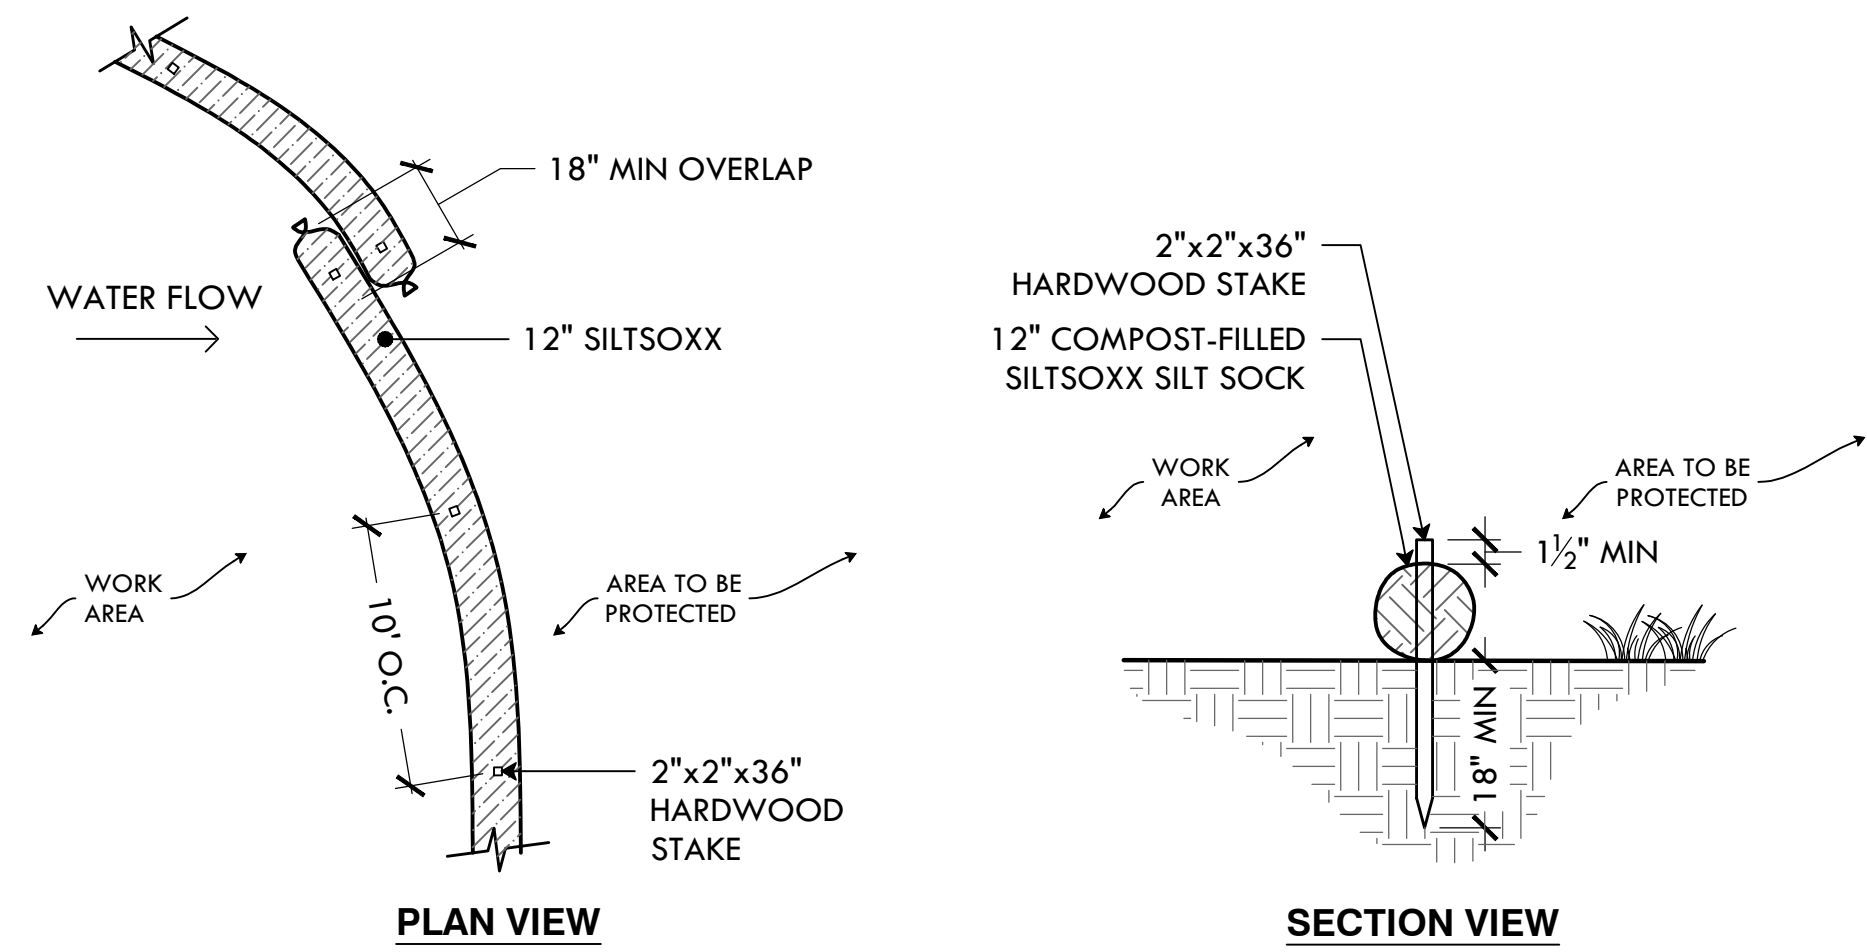

- NOTES:
1. SILT SOCK SHALL BE SILT SOCK BY FILTREXX OR LANDSCAPE ARCHITECT APPROVED EQUAL.
  2. FILL MATERIAL TO MEET MANUFACTURER'S SPECIFICATIONS.
  3. FOLLOWING CONSTRUCTION AND SITE STABILIZATION, COMPOST MATERIAL SHALL BE DISPERSED ON SITE, IN LOCATION SELECTED BY THE LANDSCAPE ARCHITECT.


## 1 SILT SOCK/COMPOST FILTER SOCK EROSION CONTROL

NTS

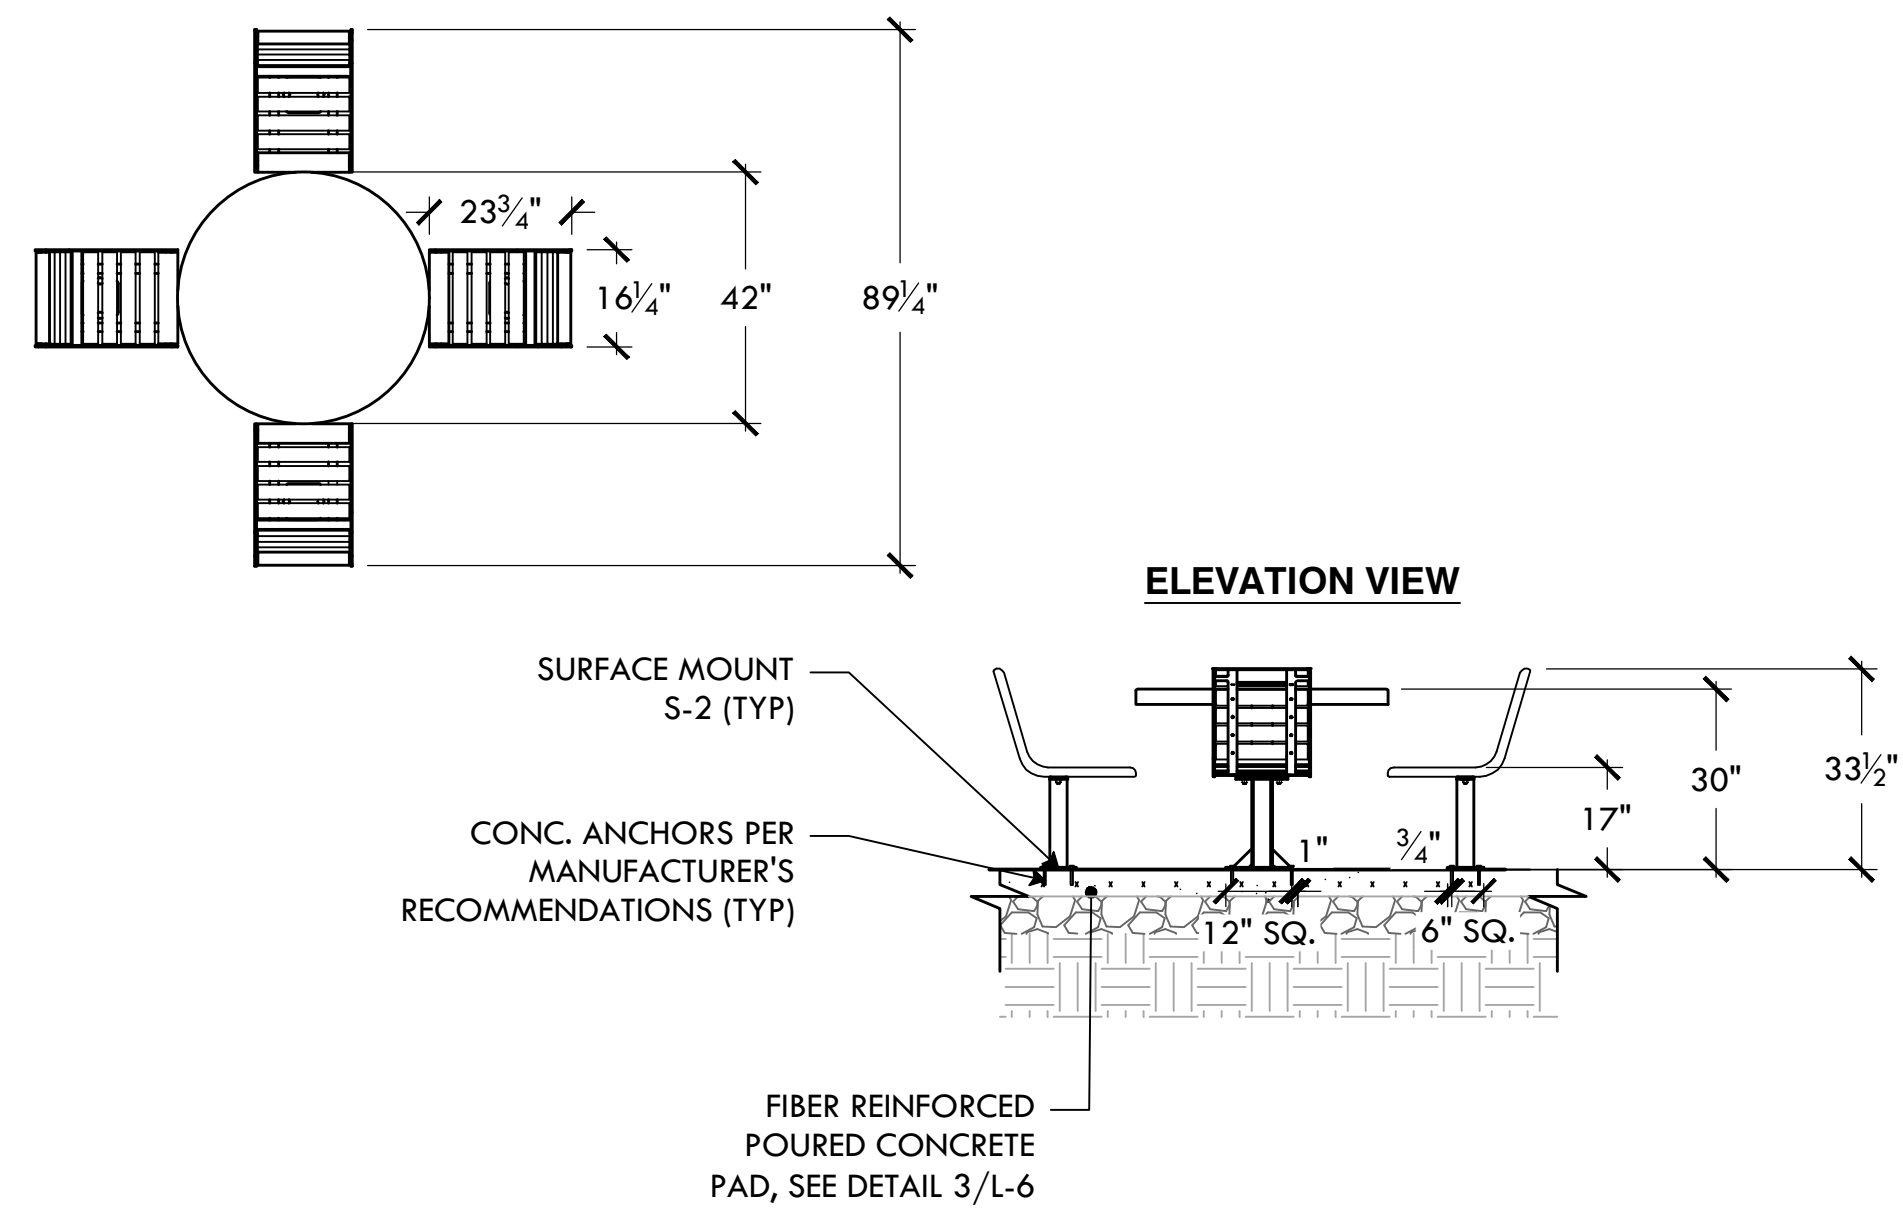


## 4 42" ROUND STEEL TABLE AND TMR CHAIRS

NTS

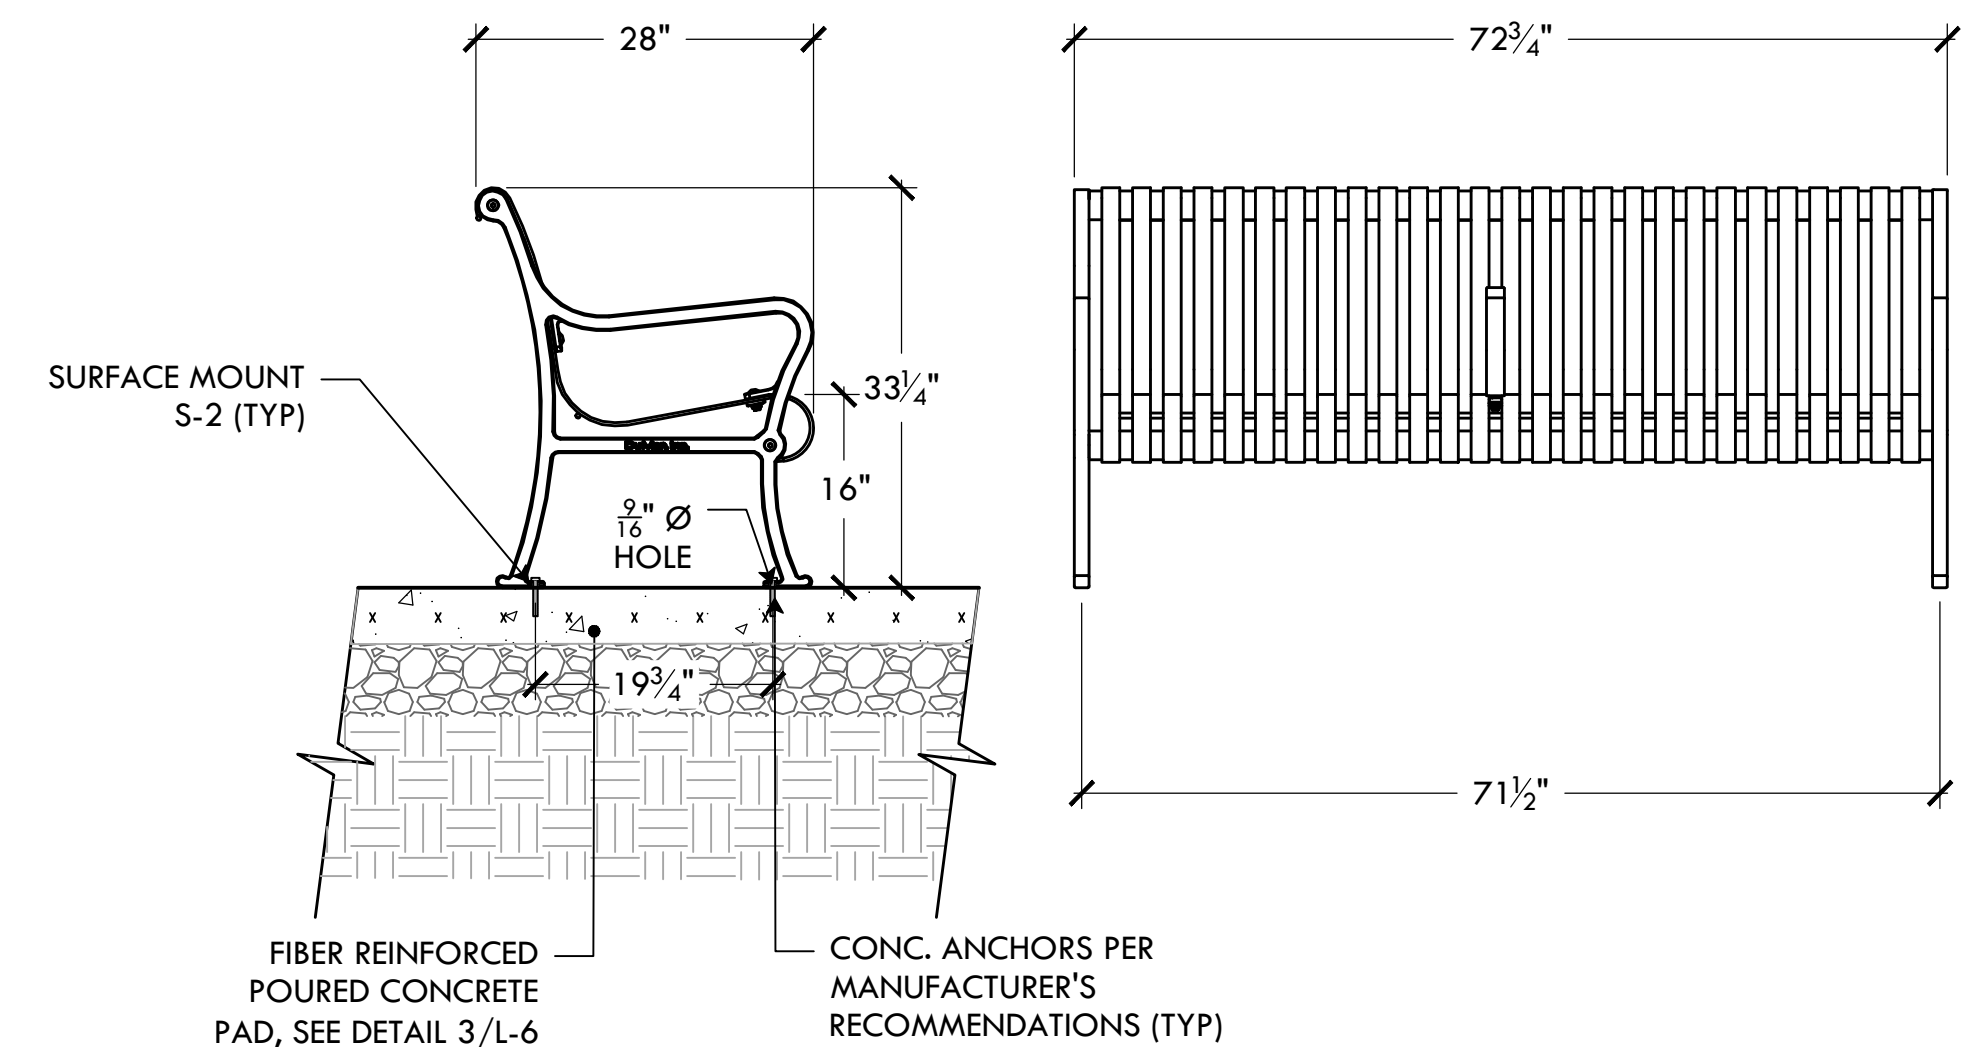


## 7 CAST STEEL BENCH

NTS

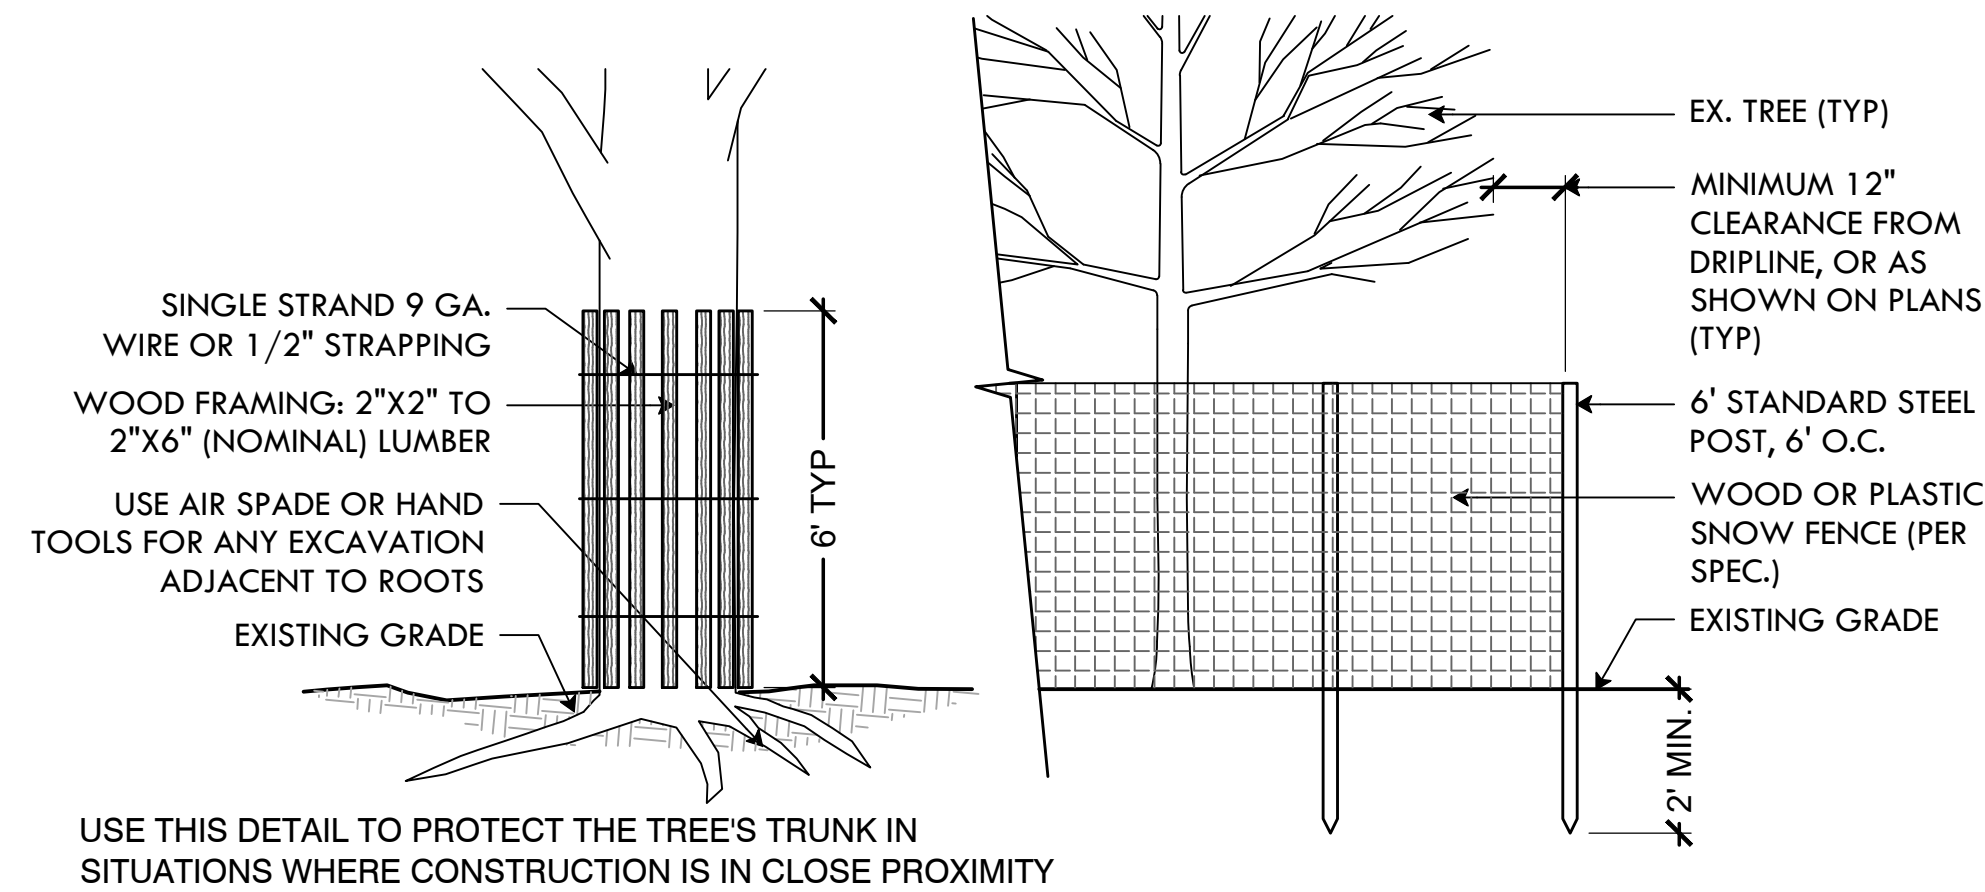

## 2 TREE PROTECTION DEVICES


NTS

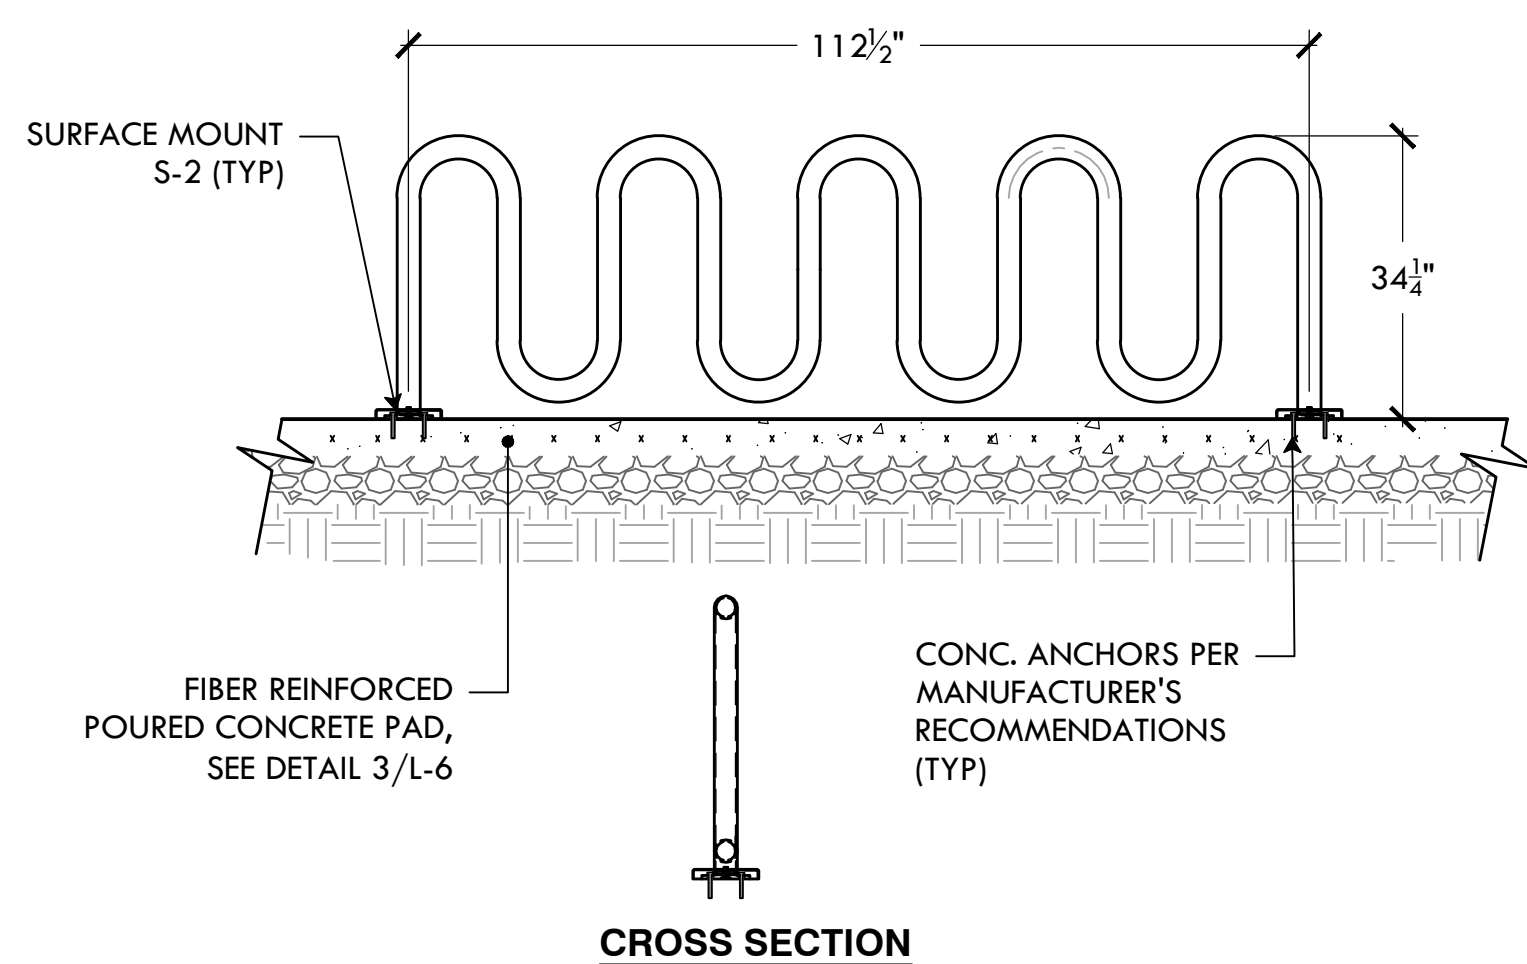

## 5 STEEL 5-PEAK BIKE RACK

NTS


GRASS SEED MIX	
30%	IMPROVED PERENNIAL RYE
30%	TURF TYPE TALL FESCUE
35%	CHEWINGS FESCUE
5%	MINIATURE OR DUTCH WHITE CLOVER

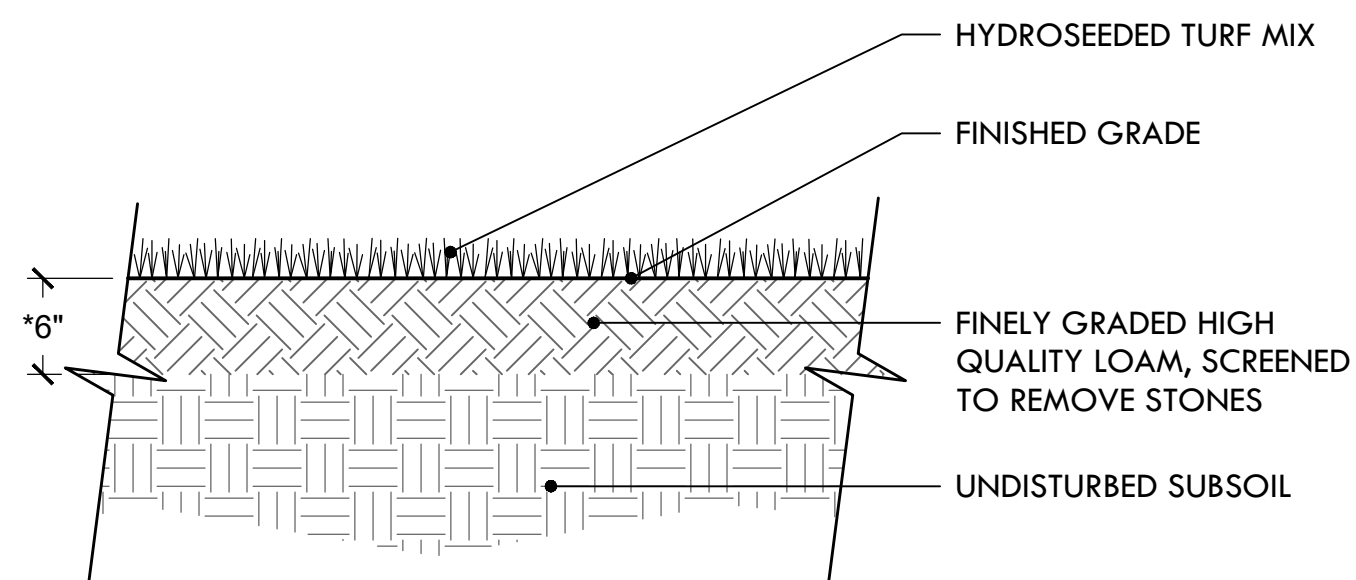

- NOTES:
1. USE A PROCESSED WOOD FIBER MULCH OR WOOD/PAPER BLEND
  2. ADD DOLOMITIC LIME AND 18-24-12 STARTER FERTILIZER TO LOAM PRIOR TO HYDROSEEDING
  3. *DEPTH OF LOAM MAY BE LESS THAN 6" IN AREAS OF TRANSITION (FEATHERING) TO EXISTING LAWN AND FOR REPAIR TO DISTURBED AREAS.
  4. LIGHTLY DISTURBED AREAS TO BE AERATED, TOP-DRESSED W/ LOAM & SLICE-SEEDED.


## 8 LOAM & HYDROSEED

NTS

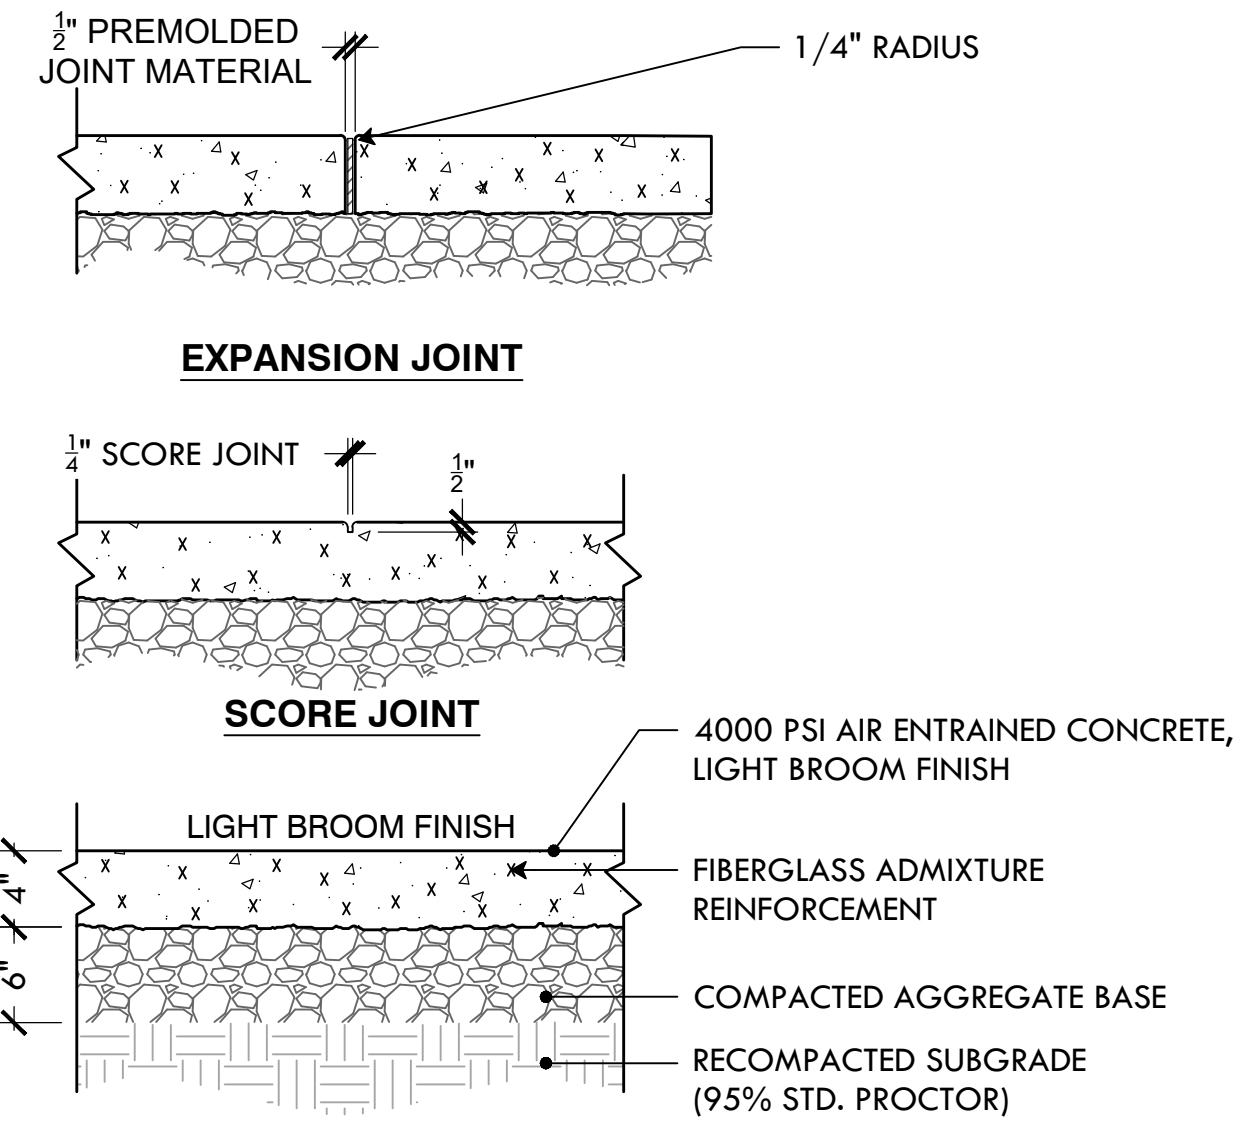


## 3 CONCRETE PAVING

NTS

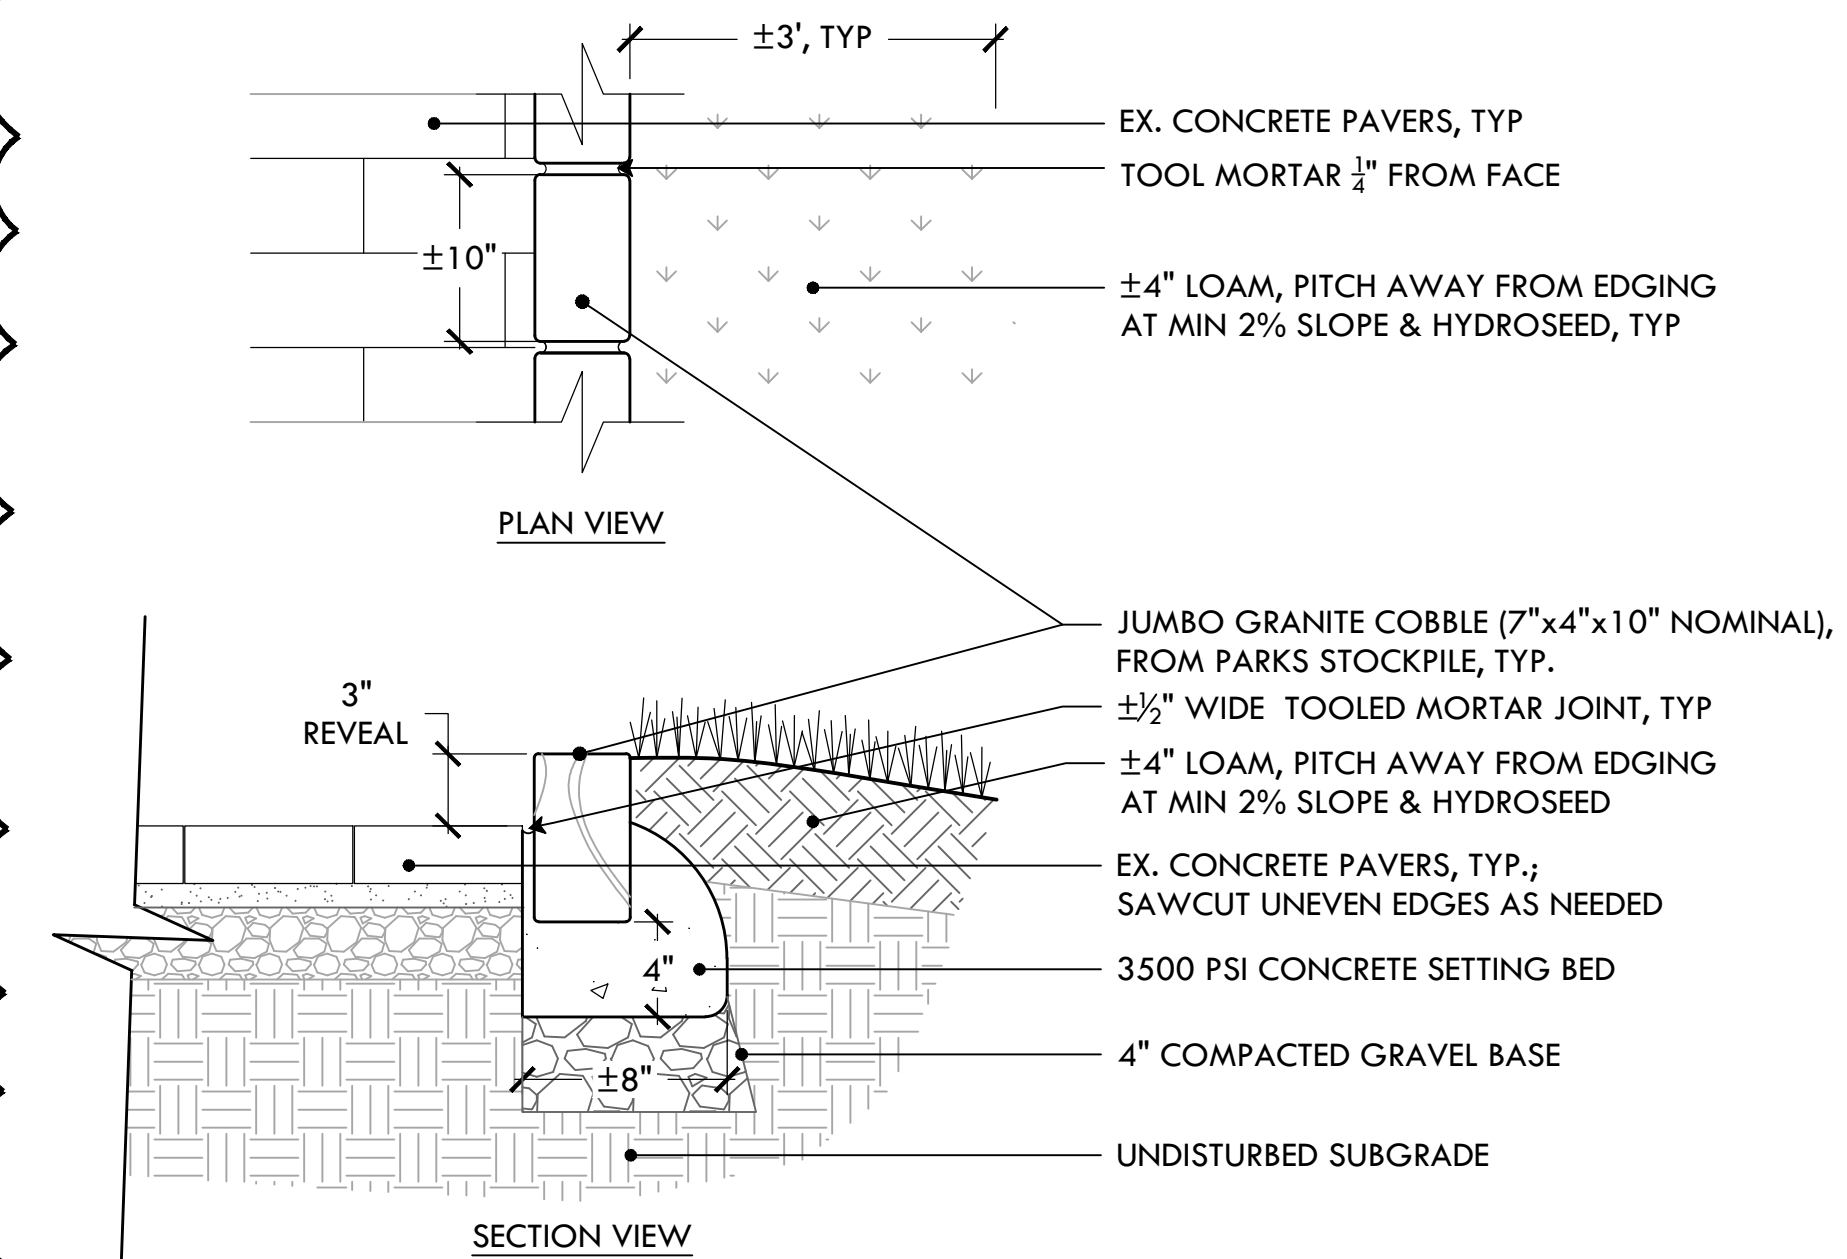

## 6 JUMBO COBBLE EDGING

NTS

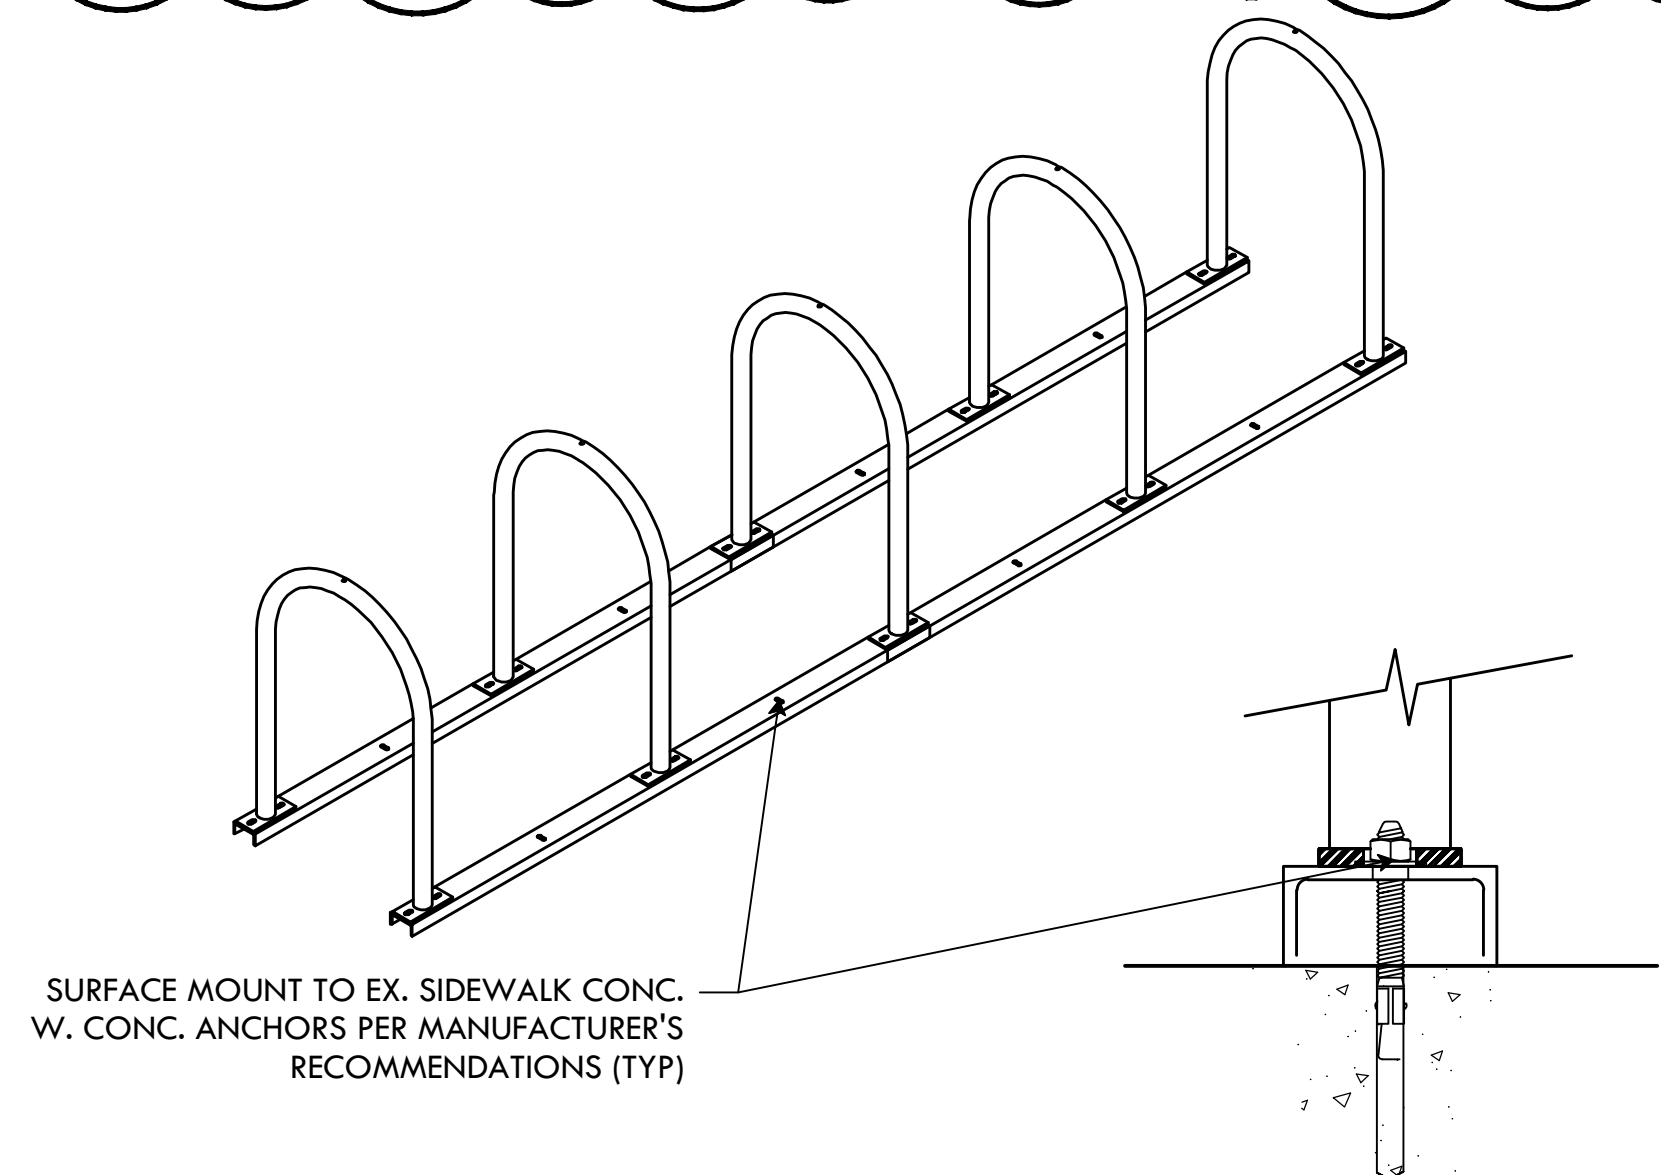

## 9 EXISTING BIKE RACK

NTS



**PROVIDENCE  
PARKS DEPARTMENT**  
DALRYMPLE BOATHOUSE  
ROGER WILLIAMS PARK  
PROVIDENCE, RI 02905



**Providence  
Parks**

COPYRIGHT (C) CITY OF  
PROVIDENCE PARKS  
DEPARTMENT, ALL RIGHTS  
RESERVED 2026.

NO PART OF THIS DOCUMENT MAY BE  
REPRODUCED, STORED IN A RETRIEVAL  
SYSTEM OR TRANSMITTED IN ANY FORM OR  
BY ANY MEANS, ELECTRONIC,  
MECHANICAL, PHOTOCOPYING,  
RECORDING OR OTHERWISE WITHOUT THE  
PRIOR WRITTEN PERMISSION OF THE CITY OF  
PROVIDENCE PARKS DEPARTMENT. ANY  
MODIFICATIONS TO THIS DOCUMENT  
WITHOUT THE WRITTEN PERMISSION OF  
THE CITY OF PROVIDENCE PARKS  
DEPARTMENT SHALL RENDER IT INVALID  
AND UNUSABLE.

**STAMP**

**PROJECT:**

**Site Improvements at  
Hopkins Sq. Park**

**465 Branch Ave  
Providence, RI**

**REVISIONS:**

#	Date	Issued For:
1	08.12.26	ADDENDUM 2
2	-	-
3	-	-

**NORTH ARROW**

**SCALE**

**DRAWING INFO**

DATE ISSUED: 07/27/2026  
PROJECT NO: HOPK.25.01  
DRAWN BY: II  
CHECKED BY: MG

**SHEET TITLE**

**Details**

**L-6**

6 OF 6

FILE: HOPK.25.01-PLANS.dwg